

This is a "PROVISIONAL BUILDING PLAN"
approved only for the purpose of inviting
objections from the general public

Checked and found ok for Public Health
(Internal) Service only subject to comments in
in forwarding letter No. ACE(HQ).....DL/17/4/23
68277

Additional Chief Engineer (HQ)
HSPV, Panchkula


Member Secretary
BPMC

Ram Avtar Bansi
AD(HQ)

P.A. A.T.P.

Member
BPMC

ELEVATION-3
GREEN AREA

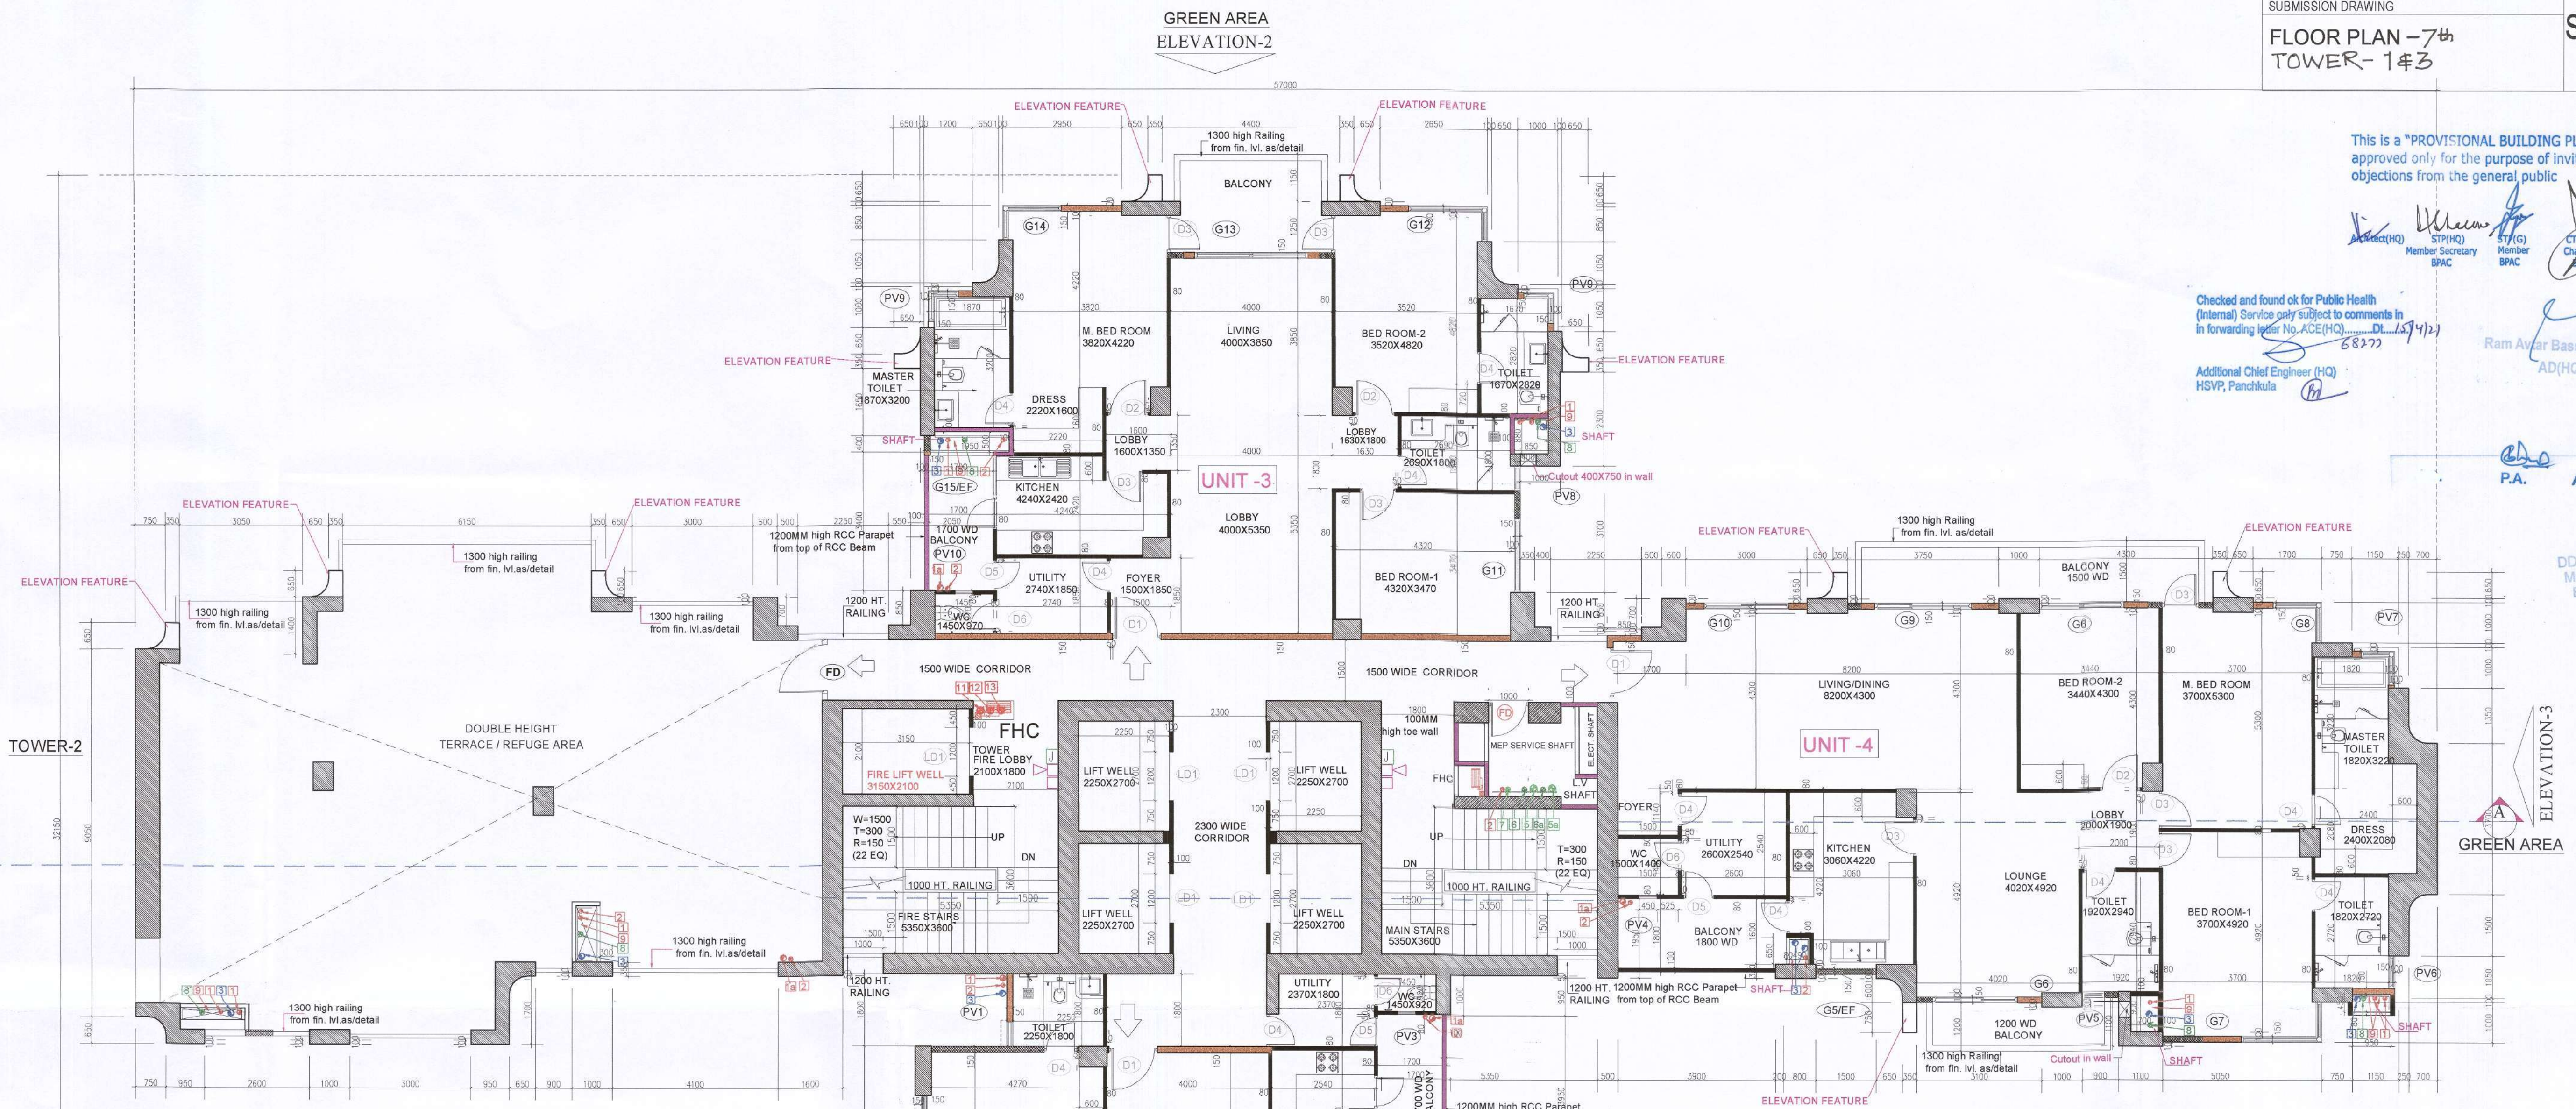

7,17 & 26 FLOOR PLAN TOWER -1 & 3

NOTE: TOWER -3 IS MIRROR OF TOWER -1

SCHEDULE OF PLUMBING PIPES:-		
PIPE NO.	DESCRIPTION	DIA. (MM)
1	SOIL & VENT PIPE MAIN TOILET	100 Dia
1a	SOIL & VENT PIPE	150 Dia
2	WASTE & VENT PIPE	100 Dia
3	RAIN WATER PIPE FOR TERRACE	150 Dia
4	RAIN WATER PIPE FOR BALCONY	100 Dia
5	CWS DROP FROM OHT	
5a	CWS DROP FROM OHT	
6	FWS DROP FROM OHT	
6a	FWS DROP FROM OHT	
7	COLD WATER RISER TO OHT	
8	FLUSHING WATER RISER TO OHT	
9	VENT PIPE	75 Dia
10	DOWN COMER FOR SPRINKLER	150 Dia
11	WET RISER FOR FIRE HYDRANTS	150 Dia
12	WET RISER FOR FIRE HYDRANTS	150 Dia
13	WET RISER FOR FIRE HYDRANTS	150 Dia
14	WET RISER FOR FIRE SPRINKLERS	150 Dia
15	WET RISER FOR FIRE SPRINKLERS	150 Dia
16	WET RISER FOR FIRE SPRINKLERS	150 Dia
17	Drain Pipe	80 Dia

LEGEND FIRE FIGHTING:-	
	FIRE HOSE CABINET
	FIREMAN'S JACK
	HOOTER
	MANUAL CALL POINT

LEGEND FIRE EXTINGUISHER	
	FIRE EXTINGUISHER ABC POWDER TYPE - CAP. 6KG.
	FIRE EXTINGUISHER BC POWDER TYPE -CAP. 9KG.

NOTE

TOWERS SHALL BE PROVIDED WITH AUTOMATIC SPRINKLERS

DOOR/WINDOW SCHEDULE TOWER-1									
UNIT	NO.	WIDTH	HEIGHT	GLAZING	UNIT	NO.	WIDTH	HEIGHT	GLAZING
UNIT-1	D1	1.2	2.4	0	2.4	1	2.88	2.0	INTERIOR DOOR
	D2	1.2	2.4	0	2.4	3	2.88	2.0	INTERIOR DOOR
	D3	0.9	2.4	0	2.4	3	2.88	2.0	INTERIOR DOOR
	D4	0.9	2.4	0	2.4	4	1.92	2.0	TOILET
	D5	0.75	2.4	0	2.4	1	1.8	2.0	TOILET
	D6	0.75	2.4	0	2.4	1	1.8	2.0	TOILET
	D7	1.2	2.4	0	2.4	1	1.8	2.0	TOILET
	D8	1.2	2.4	0	2.4	1	1.8	2.0	TOILET
	D9	1.2	2.4	0	2.4	1	1.8	2.0	TOILET
	D10	1.2	2.4	0	2.4	1	1.8	2.0	TOILET
UNIT-2	D1	1.2	2.4	0	2.4	1	2.88	2.0	INTERIOR DOOR
	D2	1.2	2.4	0	2.4	3	2.88	2.0	INTERIOR DOOR
	D3	0.9	2.4	0	2.4	3	2.88	2.0	INTERIOR DOOR
	D4	0.9	2.4	0	2.4	4	1.92	2.0	TOILET
	D5	0.75	2.4	0	2.4	1	1.8	2.0	TOILET
	D6	0.75	2.4	0	2.4	1	1.8	2.0	TOILET
	D7	1.2	2.4	0	2.4	1	1.8	2.0	TOILET
	D8	1.2	2.4	0	2.4	1	1.8	2.0	TOILET
	D9	1.2	2.4	0	2.4	1	1.8	2.0	TOILET
	D10	1.2	2.4	0	2.4	1	1.8	2.0	TOILET
UNIT-3	D1	1.2	2.4	0	2.4	1	2.88	2.0	INTERIOR DOOR
	D2	1.2	2.4	0	2.4	3	2.88	2.0	INTERIOR DOOR
	D3	0.9	2.4	0	2.4	3	2.88	2.0	INTERIOR DOOR
	D4	0.9	2.4	0	2.4	4	1.92	2.0	TOILET
	D5	0.75	2.4	0	2.4	1	1.8	2.0	TOILET
	D6	0.75	2.4	0	2.4	1	1.8	2.0	TOILET
	D7	1.2	2.4	0	2.4	1	1.8	2.0	TOILET
	D8	1.2	2.4	0	2.4	1	1.8	2.0	TOILET
	D9	1.2	2.4	0	2.4	1	1.8	2.0	TOILET
	D10	1.2	2.4	0	2.4	1	1.8	2.0	TOILET
UNIT-4	D1	1.2	2.4	0	2.4	1	2.88	2.0	INTERIOR DOOR
	D2	1.2	2.4	0	2.4	3	2.88	2.0	INTERIOR DOOR
	D3	0.9	2.4	0	2.4	3	2.88	2.0	INTERIOR DOOR
	D4	0.9	2.4	0	2.4	4	1.92	2.0	TOILET
	D5	0.75	2.4	0	2.4	1	1.8	2.0	TOILET
	D6	0.75	2.4	0	2.4	1	1.8	2.0	TOILET
	D7	1.2	2.4	0	2.4	1	1.8	2.0	TOILET
	D8	1.2	2.4	0	2.4	1	1.8	2.0	TOILET
	D9	1.2	2.4	0	2.4	1	1.8	2.0	TOILET
	D10	1.2	2.4	0	2.4	1	1.8	2.0	TOILET
TOTAL									
UNIT-1						10	26.88		
UNIT-2						10	26.88		
UNIT-3						10	26.88		
UNIT-4						10	26.88		
COMMON AREA						11	38.40		
TOTAL						41	149.04		

NOTE: D1 (UNIT ENTRY DOOR IS 1HR FIRE RATED)

PROJECT TITLE

REVISED BUILDING PLANS OF MIXED LAND USE UNDER TOD
SCHEME FOR AREA MEASURING 19.244 ACRES (LICENCE NO.
168-172 OF 2004, DATED 18/12/2004 & LICENCE NO. 545-546 OF 2006,
DATED 13/03/2006) IN SECTOR- 53, GURUGRAM MANESAR URBAN
COMPLEX BEING DEVELOPED BY M/S VIPUL LIMITED AND OTHERS.

SCALE 1:100

DATE AUG. 2021

DEALT J.P. SHARMA CHECKED VG

ARCHITECT

Design Axis
architects

T-134 A, AMY BAGH FARM HOUSE, NEAR SHAMSHI TALAB
ANDHERIA MORTH, MEHRAULA, NEW DELHI - 110030
PH - 9811059563, 26644831, 266448146
EMAIL - designaxis2015@gmail.com

ARCHITECT'S ID

designcosmos

Architects & Interior Design Consultants
Second Floor, A-609, Sushant Lok-I, Gurgaon.
Email : studio.designcosmos@gmail.com
Contact : 0124-4203676

ARCHITECT'S SIGN.

APPLICANT'S SIGN.

For VIPUL LIMITED

Authorised Signatory