

This is a "PROVISIONAL BUILDING PLAN" approved only for the purpose of inviting objections from the general public


Checked and found ok for Public Health (Internal) Services only subject to comments in forwarding letter No. AC/HQ/..... D.L. (S.H.) 2/ 68277

Additional Chief Engineer (HQ) HSNP, Panchkula

Ram Katar Bansi AD(HQ)

P.A. A.T.P.

J.D.T (HQ) Member BPAC

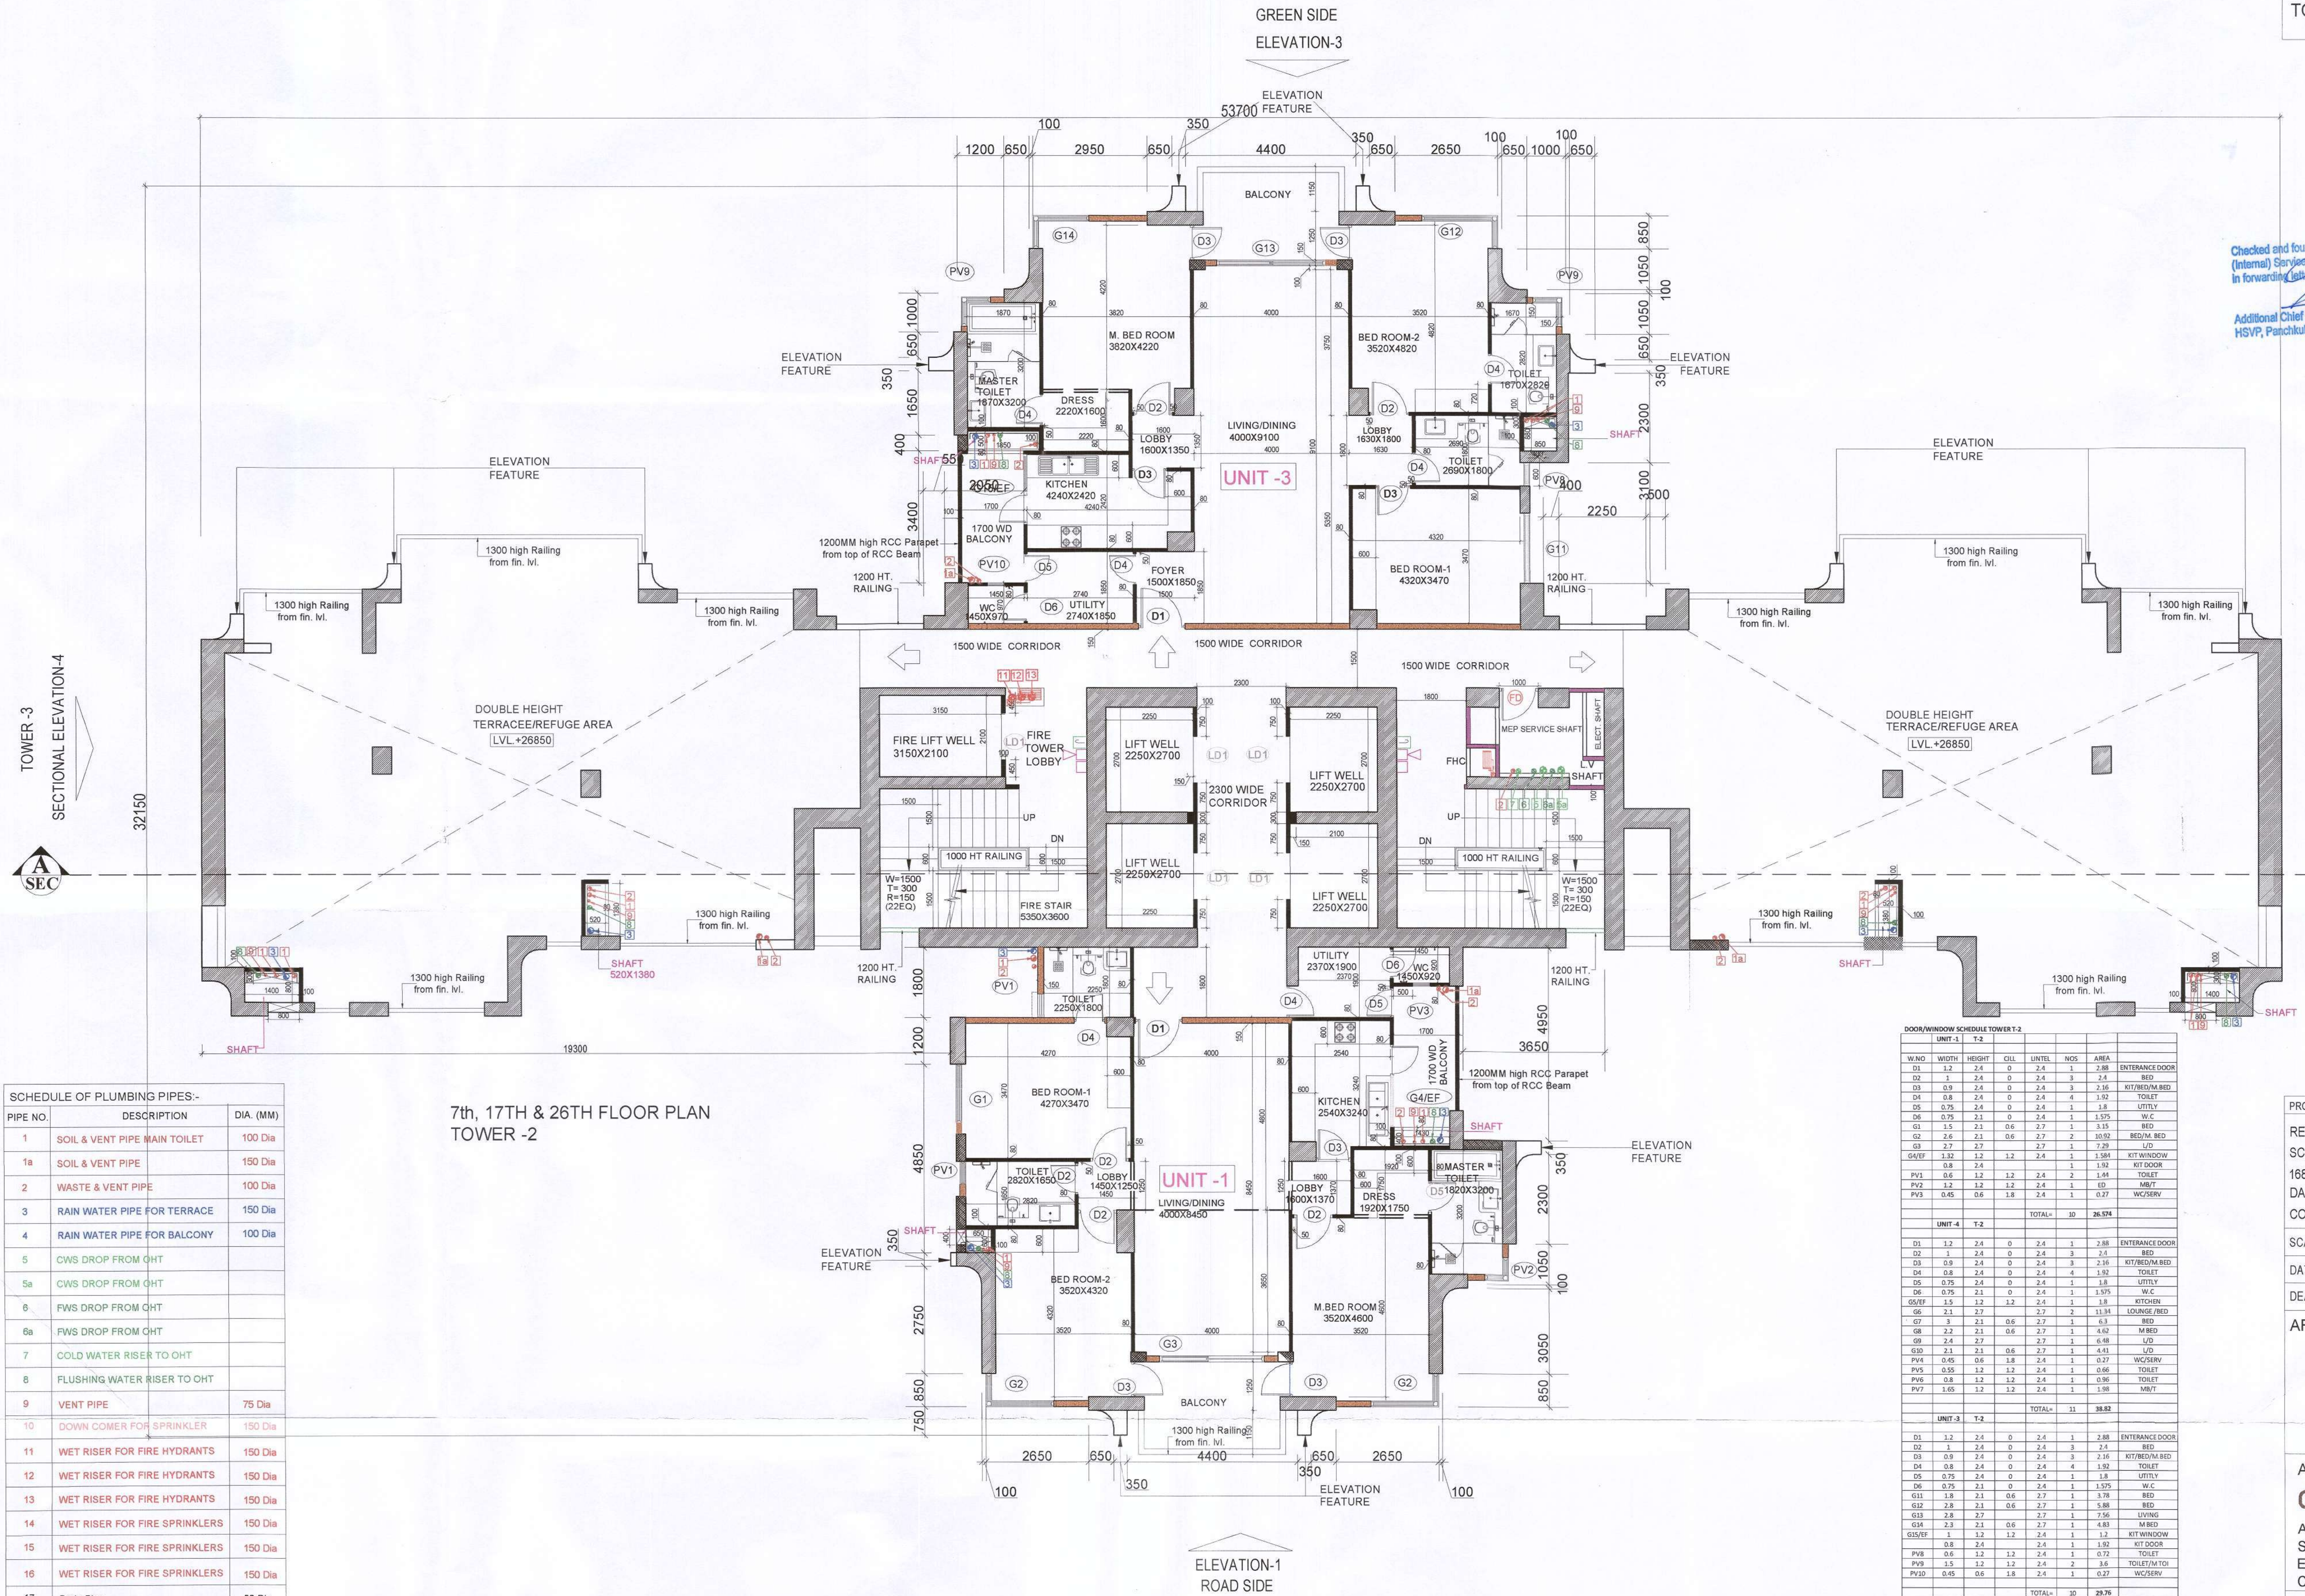

SCHEDULE OF PLUMBING PIPES:-		
PIPE NO.	DESCRIPTION	DIA. (MM)
1	SOIL & VENT PIPE MAIN TOILET	100 Dia
1a	SOIL & VENT PIPE	150 Dia
2	WASTE & VENT PIPE	100 Dia
3	RAIN WATER PIPE FOR TERRACE	150 Dia
4	RAIN WATER PIPE FOR BALCONY	100 Dia
5	CWS DROP FROM OHT	
5a	CWS DROP FROM OHT	
6	FWS DROP FROM OHT	
6a	FWS DROP FROM OHT	
7	COLD WATER RISER TO OHT	
8	FLUSHING WATER RISER TO OHT	
9	VENT PIPE	75 Dia
10	DOWN COMER FOR SPRINKLER	150 Dia
11	WET RISER FOR FIRE HYDRANTS	150 Dia
12	WET RISER FOR FIRE HYDRANTS	150 Dia
13	WET RISER FOR FIRE HYDRANTS	150 Dia
14	WET RISER FOR FIRE SPRINKLERS	150 Dia
15	WET RISER FOR FIRE SPRINKLERS	150 Dia
16	WET RISER FOR FIRE SPRINKLERS	150 Dia
17	Drain Pipe	80 Dia

LEGEND FIRE FIGHTING:-	
	FIRE HOSE CABINET
	FIREMAN'S JACK
	HOOTER
	MANUAL CALL POINT

LEGEND FIRE EXTINGUISHER	
	FIRE EXTINGUISHER ABC POWDER TYPE - CAP. 6KG.
	FIRE EXTINGUISHER BC POWDER TYPE -CAP. 9KG.

NOTE: TOWERS SHALL BE PROVIDED WITH AUTOMATIC SPRINKLERS

7th, 17TH & 26TH FLOOR PLAN
TOWER -2

DOOR/WINDOW SCHEDULE TOWER T-2											
UNIT-1 T-2											
WIND	WIDTH	HEIGHT	CILL	LINTEL	NOS.	AREA					
D1	1.2	2.4	0	2.4	1	2.88	ENTRANCE DOOR				
D2	1	2.4	0	2.4	3	2.4	BED				
D3	0.9	2.4	0	2.4	3	2.16	KIT/REAR BED				
D4	0.8	2.4	0	2.4	4	1.92	TOILET				
D5	0.75	2.4	0	2.4	1	1.8	UTILITY				
D6	0.75	2.1	0	2.1	1	1.575	W.C.				
D7	1.5	2.1	0.6	2.7	1	3.15	BED				
D8	2.6	2.1	0.6	2.7	2	10.92	REAR BED				
D9	2.7	2.7	0	2.7	1	7.29	L/D				
G1/EF	1.32	1.2	1.2	2.4	1	1.584	KIT WINDOW				
PV1	0.6	1.2	1.2	2.4	2	1.44	KIT DOOR				
PV2	1.2	1.2	1.2	2.4	1	1.8	M/BT				
PV3	0.45	0.6	1.8	2.4	1	0.27	WC/SERV				
TOTAL:-						30	26.574				

UNIT-4 T-2											
D1	1.2	2.4	0	2.4	1	2.88	ENTRANCE DOOR				
D2	1	2.4	0	2.4	3	2.4	BED				
D3	0.9	2.4	0	2.4	3	2.16	KIT/REAR BED				
D4	0.8	2.4	0	2.4	4	1.92	TOILET				
D5	0.75	2.4	0	2.4	1	1.8	UTILITY				
D6	0.75	2.1	0	2.1	1	1.575	W.C.				
G1/EF	1.5	1.2	1.2	2.4	1	1.8	KITCHEN				
D7	2.1	2.7	0	2.7	1	11.41	LOUNGE BED				
D8	3	2.1	0.6	2.7	1	6.3	BED				
D9	2.2	2.1	0.6	2.7	1	4.41	M BED				
D10	2.4	2.7	0	2.7	1	6.48	L/D				
G10	2.1	2.1	0.6	2.7	1	4.41	L/D				
PV4	0.45	0.6	1.8	2.4	1	0.27	WC/SERV				
PV5	0.55	1.2	1.2	2.4	1	0.66	TOILET				
PV6	0.8	1.2	1.2	2.4	1	0.96	TOILET				
PV7	1.05	1.2	1.2	2.4	1	1.51	UNIT				
TOTAL:-						31	38.82				

UNIT-3 T-2											
D1	1.2	2.4	0	2.4	1	2.88	ENTRANCE DOOR				
D2	1	2.4	0	2.4	3	2.4	BED				
D3	0.9	2.4	0	2.4	3	2.16	KIT/REAR BED				
D4	0.8	2.4	0	2.4	4	1.92	TOILET				
D5	0.75	2.4	0	2.4	1	1.8	UTILITY				
D6	0.75	2.1	0	2.1	1	1.575	W.C.				
G11	1.8	2.1	0.6	2.7	1	3.78	BED				
G12	1.8	2.1	0.6	2.7	1	3.78	BED				
G13	2.8	2.7	0	2.7	1	7.56	LIVING				
G14	3.3	2.1	0.6	2.7	1	4.41	M BED				
G15/EF	1	1.2	1.2	2.4	1	1.2	KIT WINDOW				
G16	0.8	2.4	0	2.4	1	1.92	KIT DOOR				
PV8	0.6	1.2	1.2	2.4	1	0.72	TOILET				
PV9	1.5	1.2	1.2	2.4	2	3.6	TOILET/M TOI				
PV10	0.45	0.6	1.8	2.4	1	0.27	WC/SERV				
TOTAL:-						30	29.76				

UNIT-2 T-2											
D1	1.2	2.4	0	2.4	1	2.88	ENTRANCE DOOR				
D2	1	2.4	0	2.4	3	2.4	BED				
D3	0.9	2.4	0	2.4	3	2.16	KIT/REAR BED				
D4	0.8	2.4	0	2.4	4	1.92	TOILET				
D5	0.75	2.4	0	2.4	1	1.8	UTILITY				
D6	0.75	2.1	0	2.1	1	1.575	W.C.				
G17	2.4	2.7	0	2.7	1	6.48	L/D				
G18	1.8	2.7	0	2.7	1	4.86	REAR BED				
G19/EF	1.5	1.2	1.2	2.4	2	5.72	KIT WINDOW				
G20	0.8	2.4	0	2.4	1	1.92	KIT DOOR				
PV11	1.8	1.2	1.2	2.4	1	1.8	M/BT				
PV12	0.6	1.2	1.2	2.4	2	1.44	TOILET/BED TOI				
PV13	0.45	0.6	1.8	2.4	1	0.27	WC/SERV				
TOTAL:-						31	33.83				

COMMON AREA T-2											
D7	1	2.1	0	2	1	2.1	SERVICES				
D10	1.1	2.1	0	2	1	2.31	MAIN/FIRE STAIRS				
G21	1.1	2.1	0	2	1	2.31	FIRE LOBBY				
G20	1	2.75	0	2.75	1	2.75	MAIN/FIRE STAIRS				
G22	1.5	1.5	1.2	2.7	1	2.25	CORRIDOR				
G23	1.4	1.5	1.2	2.7	1	2.1	CORRIDOR				
TOTAL:-						7	16.57				

NOTE: D1 (UNIT ENTRY DOOR IS 1HR FIRE RATED)

PROJECT TITLE
REVISED BUILDING PLANS OF MIXED LAND USE UNDER TOD
SCHEME FOR AREA MEASURING 19.244 ACRES (LICENCE NO.
168-172 OF 2004, DATED 16/12/2004 & LICENCE NO. 545-546 OF 2006,
DATED 13/03/2006) IN SECTOR- 53, GURUGRAM MANESAR URBAN
COMPLEX BEING DEVELOPED BY M/S VIPUL LIMITED AND OTHERS.

SCALE 1:100
DATE AUG. 2021
DEALT J.P SHARMA CHECKED VG

ARCHITECT
Design Axis
architects
T-134 A AM BAGH FARM HOUSE, NEAR SHANSHI TALAB
ANDHERIA MORH, MEHRAULI, NEW DELHI - 110030
PH - 9811058563, 26644831, 26648146
EMAIL - designaxis2015@gmail.com

ARCHITECT'S ID
designcosmos
Architects & Interior Design Consultants
Second Floor, A-609, Sushant Lok-I, Gurgaon.
Email : studio.designcosmos@gmail.com
Contact : 0124-4203676

ARCHITECT'S SIGN.

APPLICANT'S SIGN.

For Vipul Limited
Authorised Signatory