

This is a "PROVISIONAL BUILDING PLAN"
approved only for the purpose of inviting
objections from the general public


Checked and found ok for Public Health
(Internal) Service only subject to comments in
in forwarding letter to ACE(HQ).....D.....15/7/17
68277

Additional Chief Engineer (HQ)
HSPV, Panchkula

AD(HQ)

P.A. A.T.P.

AD(HQ)
Member
BMC

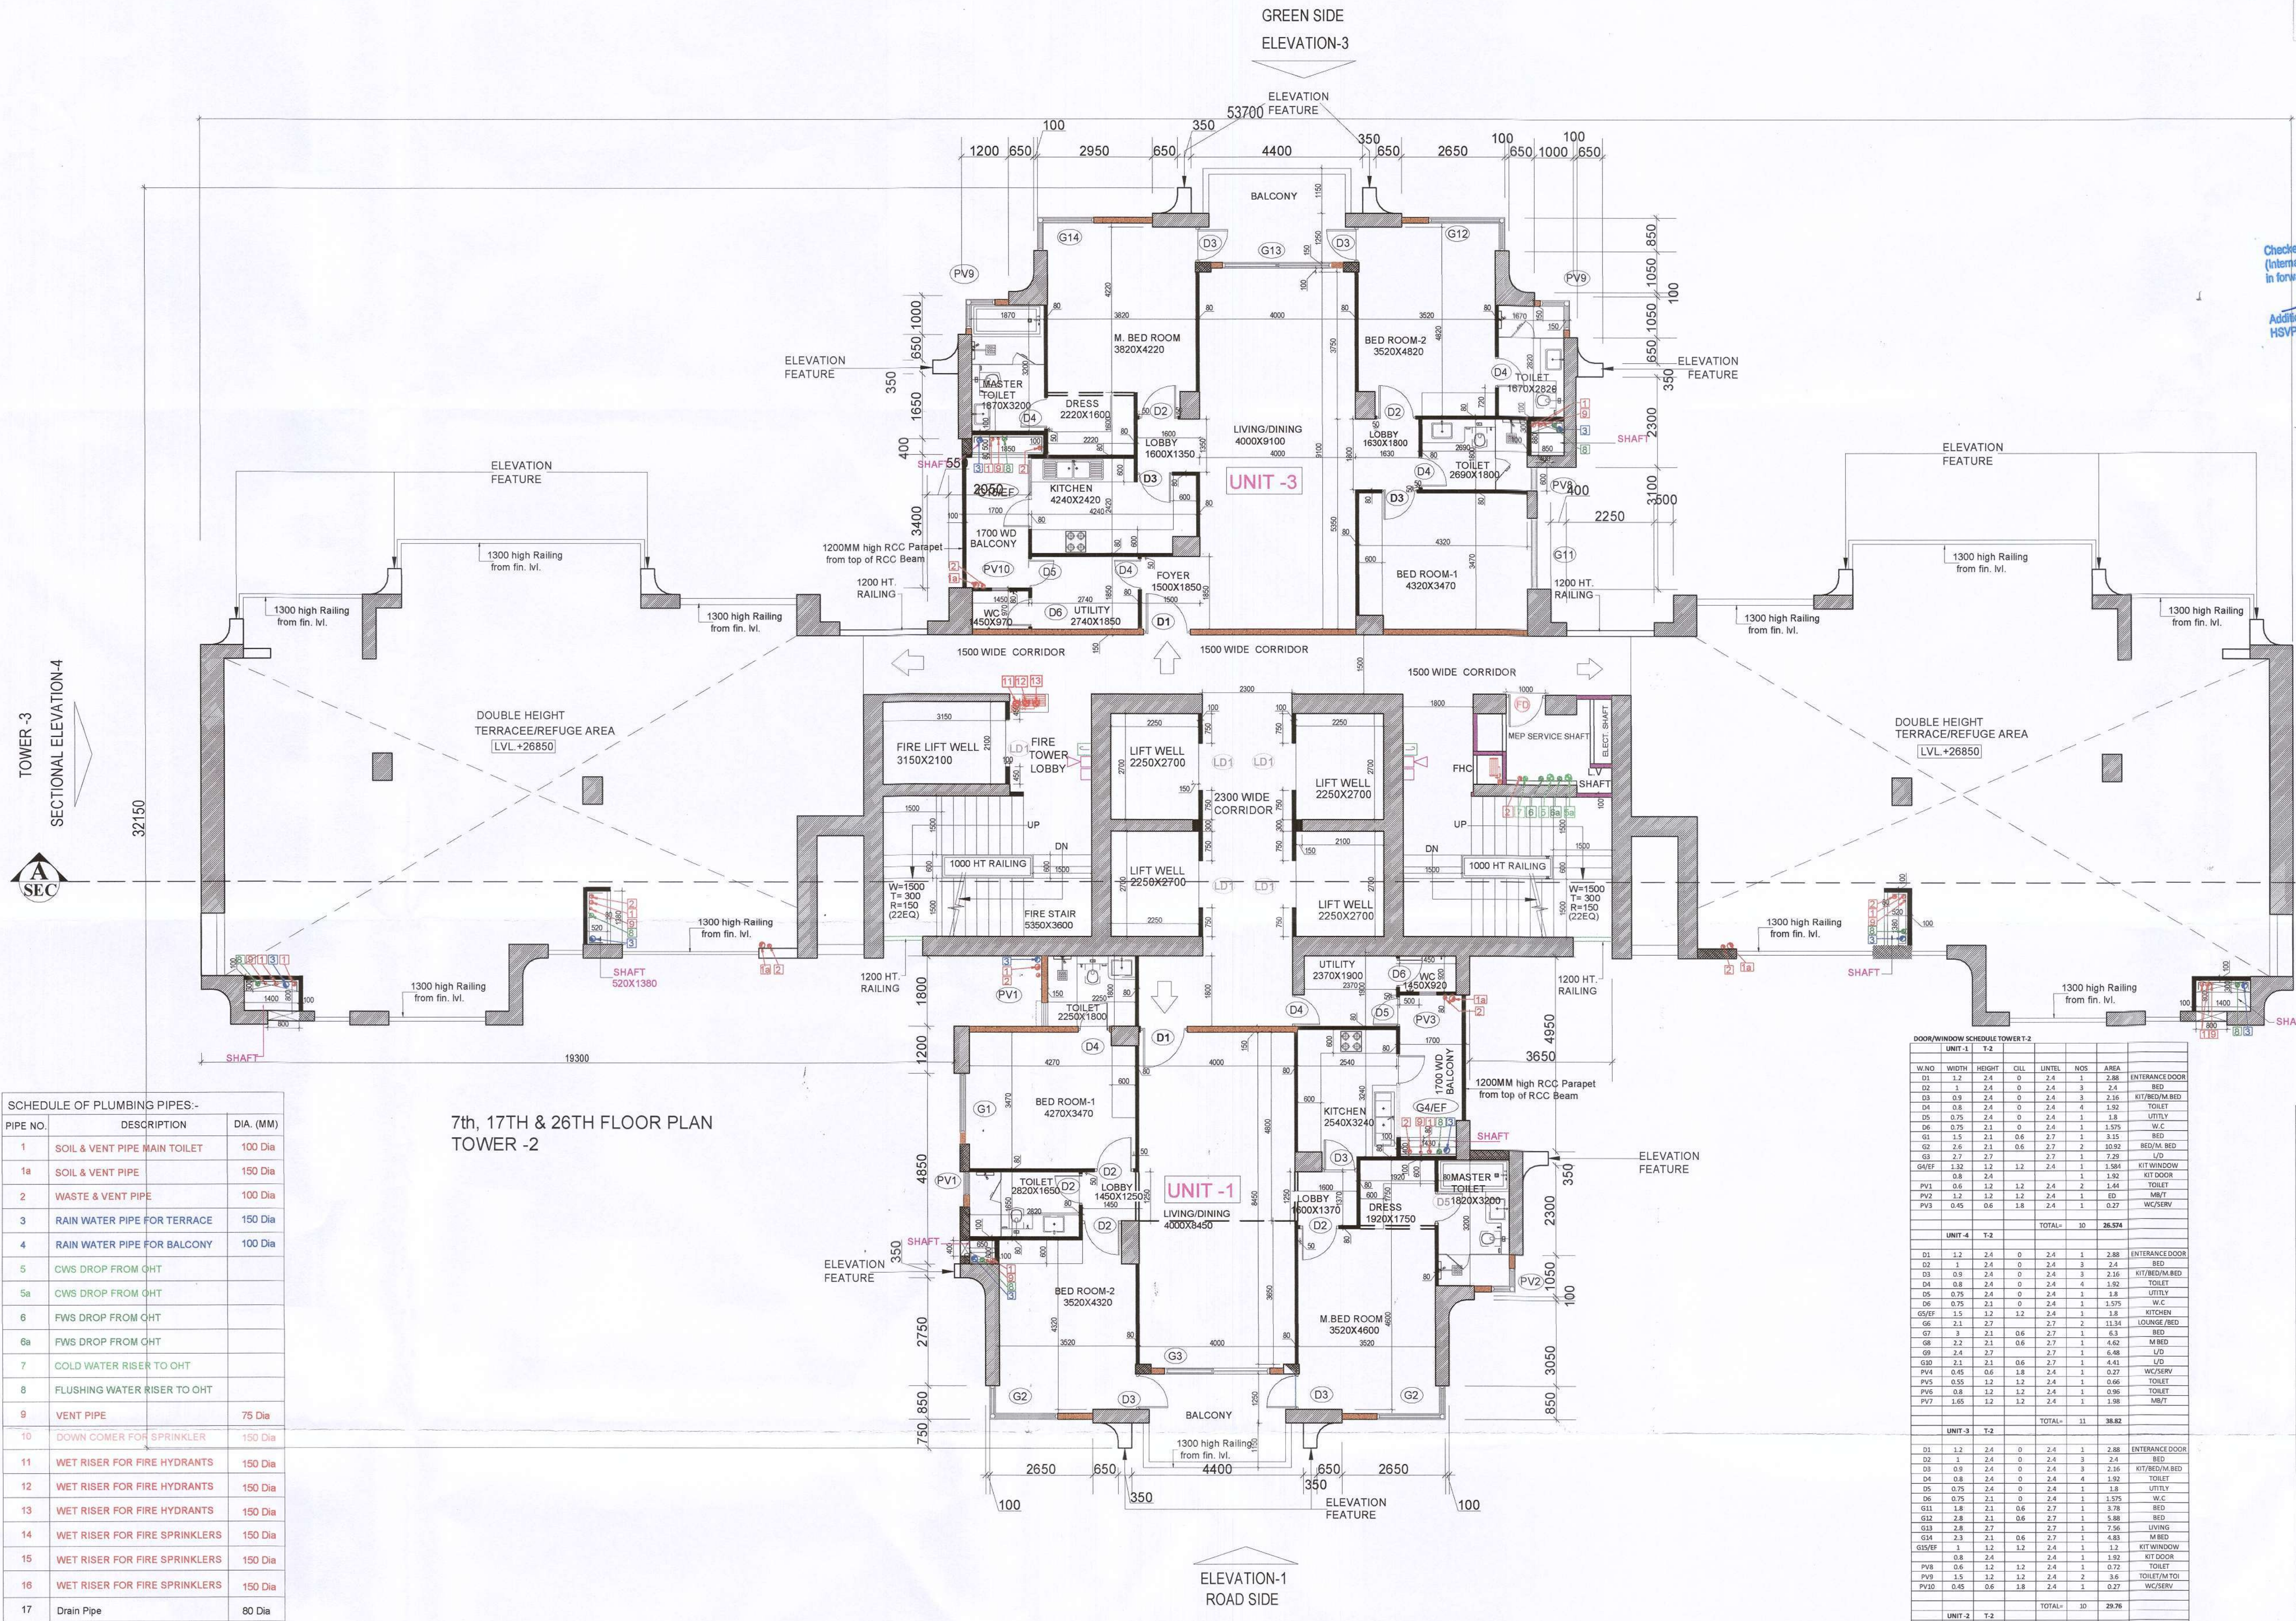

SCHEDULE OF PLUMBING PIPES:-		
PIPE NO.	DESCRIPTION	DIA. (MM)
1	SOIL & VENT PIPE MAIN TOILET	100 Dia
1a	SOIL & VENT PIPE	150 Dia
2	WASTE & VENT PIPE	100 Dia
3	RAIN WATER PIPE FOR TERRACE	150 Dia
4	RAIN WATER PIPE FOR BALCONY	100 Dia
5	CWS DROP FROM OHT	
5a	CWS DROP FROM OHT	
6	FWS DROP FROM OHT	
6a	FWS DROP FROM OHT	
7	COLD WATER RISER TO OHT	
8	FLUSHING WATER RISER TO OHT	
9	VENT PIPE	75 Dia
10	DOWN COMER FOR SPRINKLER	150 Dia
11	WET RISER FOR FIRE HYDRANTS	150 Dia
12	WET RISER FOR FIRE HYDRANTS	150 Dia
13	WET RISER FOR FIRE HYDRANTS	150 Dia
14	WET RISER FOR FIRE SPRINKLERS	150 Dia
15	WET RISER FOR FIRE SPRINKLERS	150 Dia
16	WET RISER FOR FIRE SPRINKLERS	150 Dia
17	Drain Pipe	80 Dia

LEGEND FIRE FIGHTING:-	
	FIRE HOSE CABINET
	FIREMAN'S JACK
	HOOTER
	MANUAL CALL POINT

LEGEND FIRE EXTINGUISHER	
	FIRE EXTINGUISHER ABC POWDER TYPE - CAP. 6KG.
	FIRE EXTINGUISHER BC POWDER TYPE - CAP. 9KG.

NOTE TOWERS SHALL BE PROVIDED WITH AUTOMATIC SPRINKLERS

7th, 17TH & 26TH FLOOR PLAN
TOWER -2

DOOR/WINDOW SCHEDULE TOWER-2									
UNIT-1 T-2									
W.NO	WIDTH	HEIGHT	CILL	LINTEL	NOS	AREA			
D1	1.2	2.4	0	2.4	3	2.88	ENTRANCE DOOR		
D2	1	2.4	0	2.4	3	2.4	RED		
D3	0.9	2.4	0	2.4	3	2.16	KIT/BEDRM BED		
D4	0.8	2.4	0	2.4	4	1.92	TOILET		
D5	0.75	2.4	0	2.4	1	1.8	UTILITY		
D6	0.75	2.1	0	2.4	1	1.575	W.C.		
G1	1.5	2.1	0.6	2.7	1	3.15	RED		
G2	2.6	2.1	0.6	2.7	2	10.50	BEDRM BED		
G3	2.7	2.7	1	2.7	1	7.29	LID		
G4/EF	1.32	1.2	1.2	2.4	1	1.584	KIT WINDOW		
PV1	0.6	1.2	1.2	2.4	2	1.44	TOILET		
PV2	1.2	1.2	1.2	2.4	1	3.6	KIT		
PV3	0.45	0.6	1.8	2.4	1	0.27	W.C/SERV		
TOTAL=							36.504		

UNIT-4 T-2									
D1	1.2	2.4	0	2.4	3	2.88	ENTRANCE DOOR		
D2	1	2.4	0	2.4	3	2.4	RED		
D3	0.9	2.4	0	2.4	3	2.16	KIT/BEDRM BED		
D4	0.8	2.4	0	2.4	4	1.92	TOILET		
D5	0.75	2.4	0	2.4	1	1.8	UTILITY		
D6	0.75	2.1	0	2.4	1	1.575	W.C.		
G1	1.5	1.2	1.2	2.4	1	1.8	RED		
G2	2.6	2.1	0.6	2.7	2	10.50	BEDRM BED		
G3	2.7	2.7	1	2.7	1	7.29	LID		
G4/EF	1.32	1.2	1.2	2.4	1	1.584	KIT WINDOW		
PV1	0.6	1.2	1.2	2.4	2	1.44	TOILET		
PV2	1.2	1.2	1.2	2.4	1	3.6	KIT		
PV3	0.45	0.6	1.8	2.4	1	0.27	W.C/SERV		
TOTAL=							36.504		

UNIT-3 T-2									
D1	1.2	2.4	0	2.4	3	2.88	ENTRANCE DOOR		
D2	1	2.4	0	2.4	3	2.4	RED		
D3	0.9	2.4	0	2.4	3	2.16	KIT/BEDRM BED		
D4	0.8	2.4	0	2.4	4	1.92	TOILET		
D5	0.75	2.4	0	2.4	1	1.8	UTILITY		
D6	0.75	2.1	0	2.4	1	1.575	W.C.		
G1	1.5	1.2	1.2	2.4	1	1.8	RED		
G2	2.6	2.1	0.6	2.7	2	10.50	BEDRM BED		
G3	2.7	2.7	1	2.7	1	7.29	LID		
G4/EF	1.32	1.2	1.2	2.4	1	1.584	KIT WINDOW		
PV1	0.6	1.2	1.2	2.4	2	1.44	TOILET		
PV2	1.2	1.2	1.2	2.4	1	3.6	KIT		
PV3	0.45	0.6	1.8	2.4	1	0.27	W.C/SERV		
TOTAL=							36.504		

UNIT-2 T-2									
D1	1.2	2.4	0	2.4	3	2.88	ENTRANCE DOOR		
D2	1	2.4	0	2.4	3	2.4	RED		
D3	0.9	2.4	0	2.4	3	2.16	KIT/BEDRM BED		
D4	0.8	2.4	0	2.4	4	1.92	TOILET		
D5	0.75	2.4	0	2.4	1	1.8	UTILITY		
D6	0.75	2.1	0	2.4	1	1.575	W.C.		
G1	1.5	1.2	1.2	2.4	1	1.8	RED		
G2	2.6	2.1	0.6	2.7	2	10.50	BEDRM BED		
G3	2.7	2.7	1	2.7	1	7.29	LID		
G4/EF	1.32	1.2	1.2	2.4	1	1.584	KIT WINDOW		
PV1	0.6	1.2	1.2	2.4	2	1.44	TOILET		
PV2	1.2	1.2	1.2	2.4	1	3.6	KIT		
PV3	0.45	0.6	1.8	2.4	1	0.27	W.C/SERV		
TOTAL=							36.504		

UNIT-1 T-2									
D1	1.2	2.4	0	2.4	3	2.88	ENTRANCE DOOR		
D2	1	2.4	0	2.4	3	2.4	RED		
D3	0.9	2.4	0	2.4	3	2.16	KIT/BEDRM BED		
D4	0.8	2.4	0	2.4	4	1.92	TOILET		
D5	0.75	2.4	0	2.4	1	1.8	UTILITY		
D6	0.75	2.1	0	2.4	1	1.575	W.C.		
G1	1.5	1.2	1.2	2.4	1	1.8	RED		
G2	2.6	2.1	0.6	2.7	2	10.50	BEDRM BED		
G3	2.7	2.7	1	2.7	1	7.29	LID		
G4/EF	1.32	1.2	1.2	2.4	1	1.584	KIT WINDOW		
PV1	0.6	1.2	1.2	2.4	2	1.44	TOILET		
PV2	1.2	1.2	1.2	2.4	1	3.6	KIT		
PV3	0.45	0.6	1.8	2.4	1	0.27	W.C/SERV		
TOTAL=							36.504		

COMMON AREA T-2									
D1	1.2	2.4	0	2.4	3	2.88	ENTRANCE DOOR		
D2	1	2.4	0	2.4	3	2.4	RED		
D3	0.9	2.4	0	2.4	3	2.16	KIT/BEDRM BED		
D4	0.8	2.4	0	2.4	4	1.92	TOILET		
D5	0.75	2.4	0	2.4	1	1.8	UTILITY		
D6	0.75	2.1	0	2.4	1	1.575	W.C.		
G1	1.5	1.2	1.2	2.4	1	1.8	RED		
G2	2.6	2.1	0.6	2.7	2	10.50	BEDRM BED		
G3	2.7	2.7	1	2.7	1	7.29	LID		
G4/EF	1.32	1.2	1.2	2.4	1	1.584	KIT WINDOW		
PV1	0.6	1.2	1.2	2.4	2	1.44	TOILET		
PV2	1.2	1.2	1.2	2.4	1	3.6	KIT		
PV3	0.45	0.6	1.8	2.4	1	0.27	W.C/SERV		
TOTAL=							36.504		

COMMON AREA T-2									
D1	1.2	2.4	0	2.4	3	2.88	ENTRANCE DOOR		
D2	1	2.4	0	2.4	3	2.4	RED		
D3	0.9	2.4	0	2.4	3	2.16	KIT/BEDRM BED		
D4	0.8	2.4	0	2.4	4	1.92	TOILET		
D5	0.75	2.4	0	2.4	1	1.8	UTILITY		
D6	0.75	2.1	0	2.4	1	1.575	W.C.		
G1	1.5	1.2	1.2	2.4	1	1.8	RED		
G2	2.6	2.1	0.6	2.7	2	10.50	BEDRM BED		
G3	2.7	2.7	1	2.7	1	7.29	LID		
G4/EF	1.32	1.2	1.2	2.4	1	1.584	KIT WINDOW		
PV1	0.6	1.2	1.2	2.4	2	1.44	TOILET		
PV2	1.2	1.2	1.2	2.4	1	3.6	KIT		
PV3	0.45	0.6	1.8	2.4	1	0.27	W.C/SERV		
TOTAL=							36.504		

NOTE: D1 (UNIT ENTRY DOOR IS 1HR FIRE RATED)

PROJECT TITLE
REVISED BUILDING PLANS OF MIXED LAND USE UNDER TOD
SCHEME FOR AREA MEASURING 19.244 ACRES (LICENCE NO.
168-172 OF 2004, DATED 16/12/2004 & LICENCE NO. 545-546 OF 2006,
DATED 13/03/2006) IN SECTOR- 53, GURUGRAM MANESAR URBAN
COMPLEX BEING DEVELOPED BY M/S VIPUL LIMITED AND OTHERS.

SCALE 1:100
DATE AUG. 2021
DEALT J.P. SHARMA CHECKED VG

ARCHITECT
Design Axis
architects
T-134/A, AM BAGH FARM HOUSE, NEAR SHAMSHI TALAB
ANDHERIA MORTH, MEHRAULA, NEW DELHI - 110030
PH - 9811058563, 26644831, 266484146
EMAIL - designaxis2015@gmail.com

ARCHITECT'S ID
designcosmos
Architects & Interior Design Consultants
Second Floor, A-609, Sushant Lok-I, Gurgaon.
Email : studio.designcosmos@gmail.com
Contact : 0124-4203676

ARCHITECT'S SIGN.

APPLICANT'S SIGN.

For VIPUL LIMITED
Authorised Signatory