


Checked and found ok for Public Health (Internal) Service only subject to comments in forwarding letter No. ACE/HQ/.....DL-15/17/68277
Additional Chief Engineer (HQ) HSVP, Panhala

This is a "PROVISIONAL BUILDING PLAN approved only for the purpose of inviting objections from the general public"


Member Secretary
Member Secretary
Member Secretary
Member Secretary

Ram Avtar Bassi
AD(HQ)
P.A.
A.T.P.

Member Secretary
Member Secretary

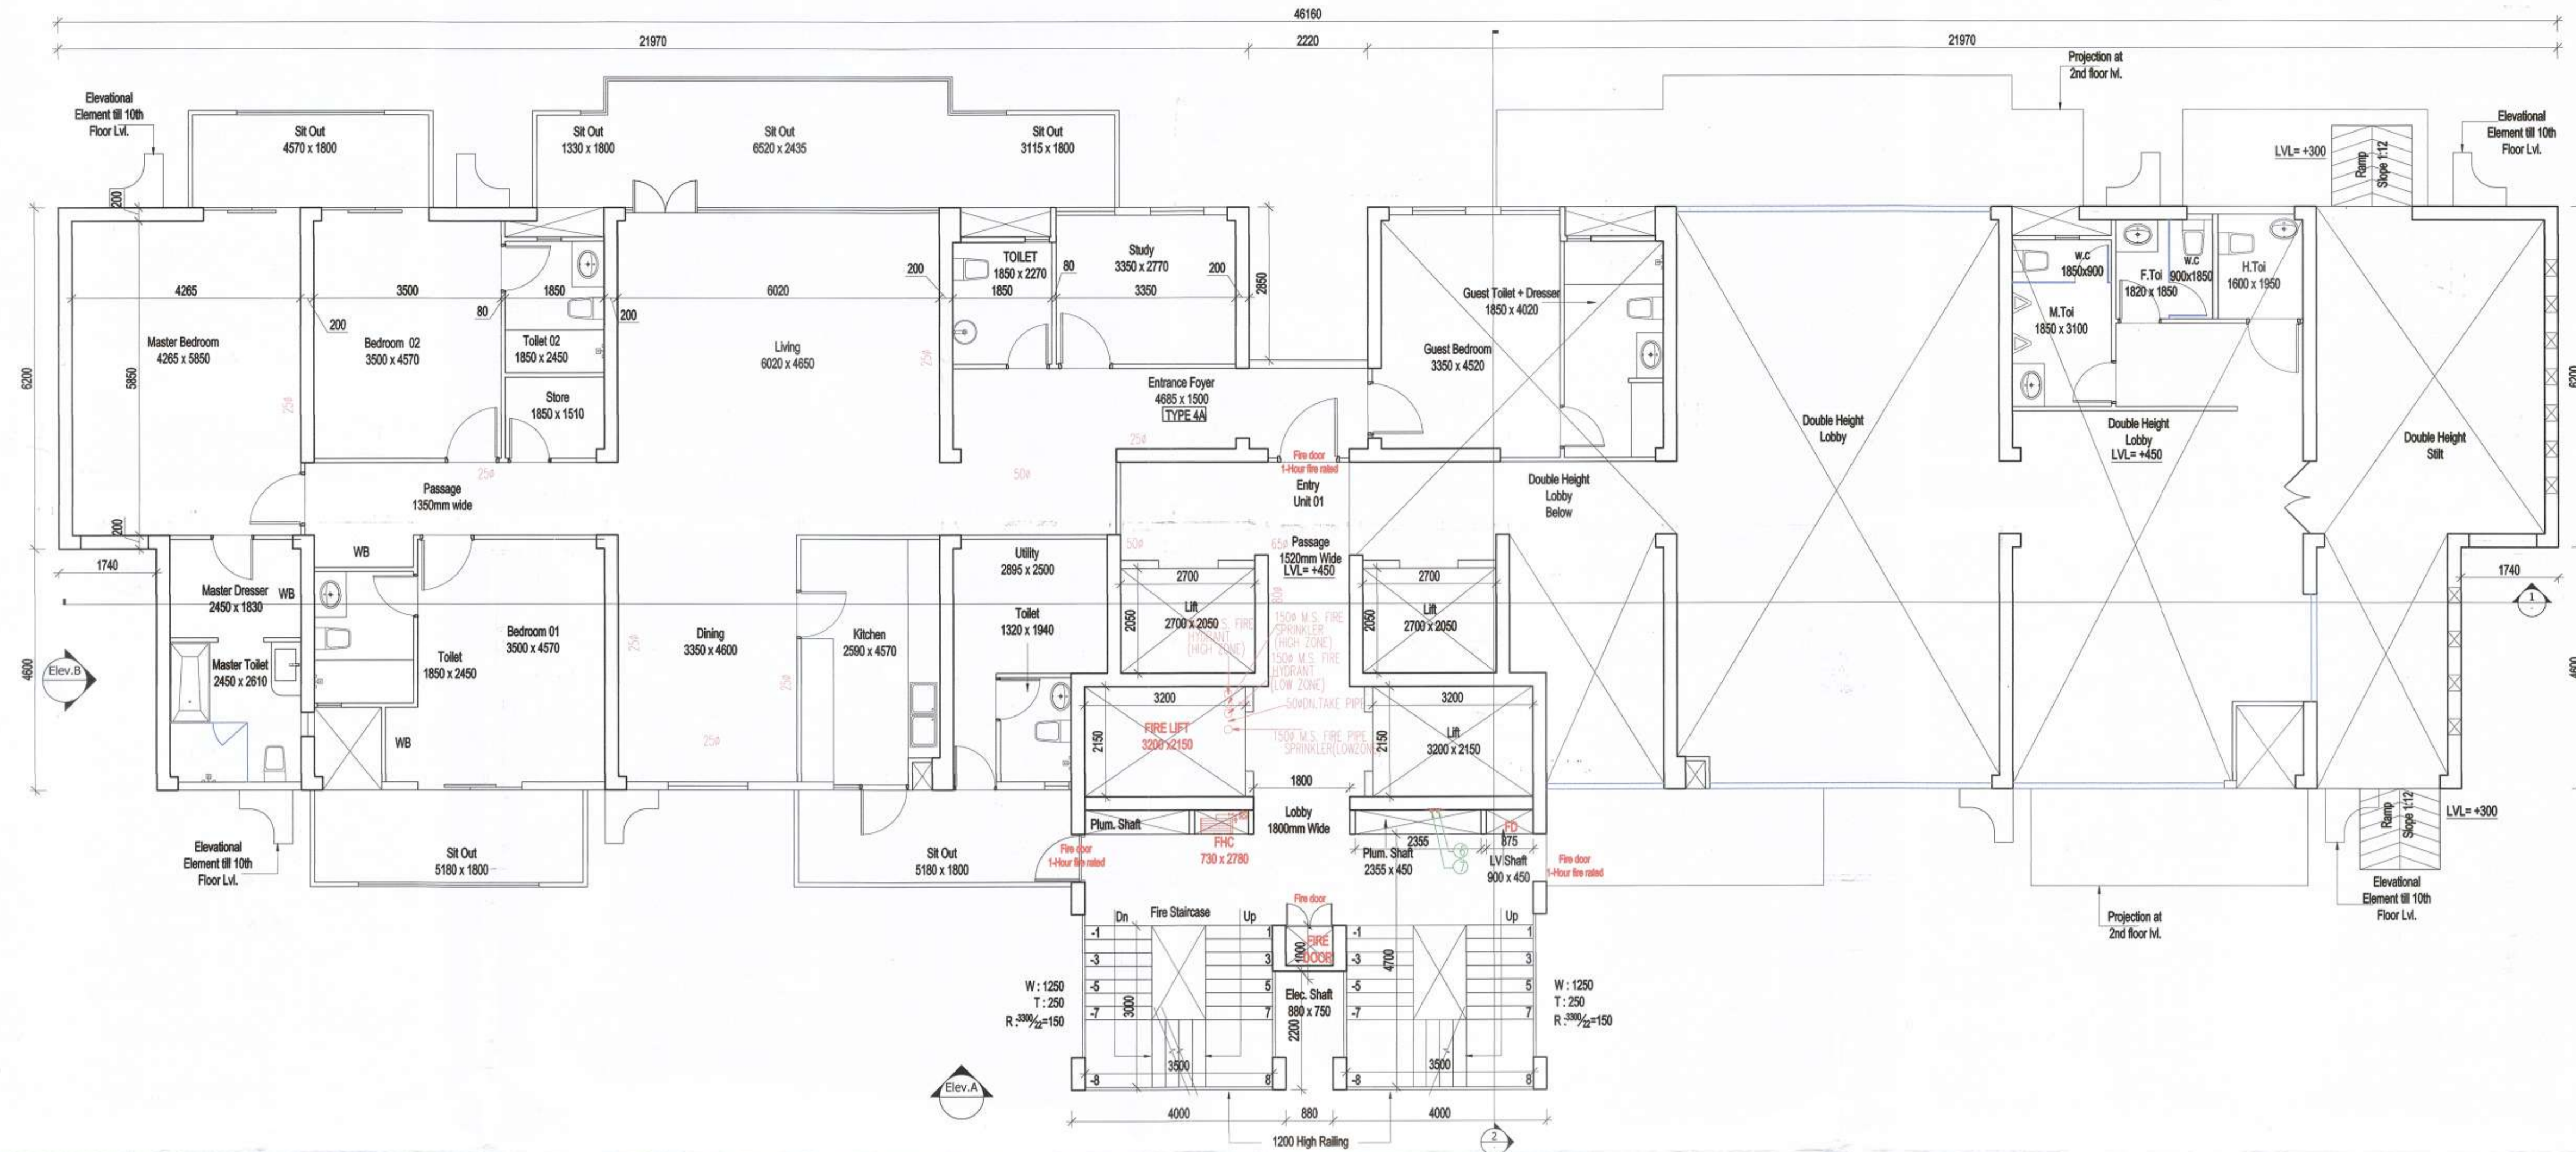

1 Ground/Stilt floor plan
SCALE - NTS

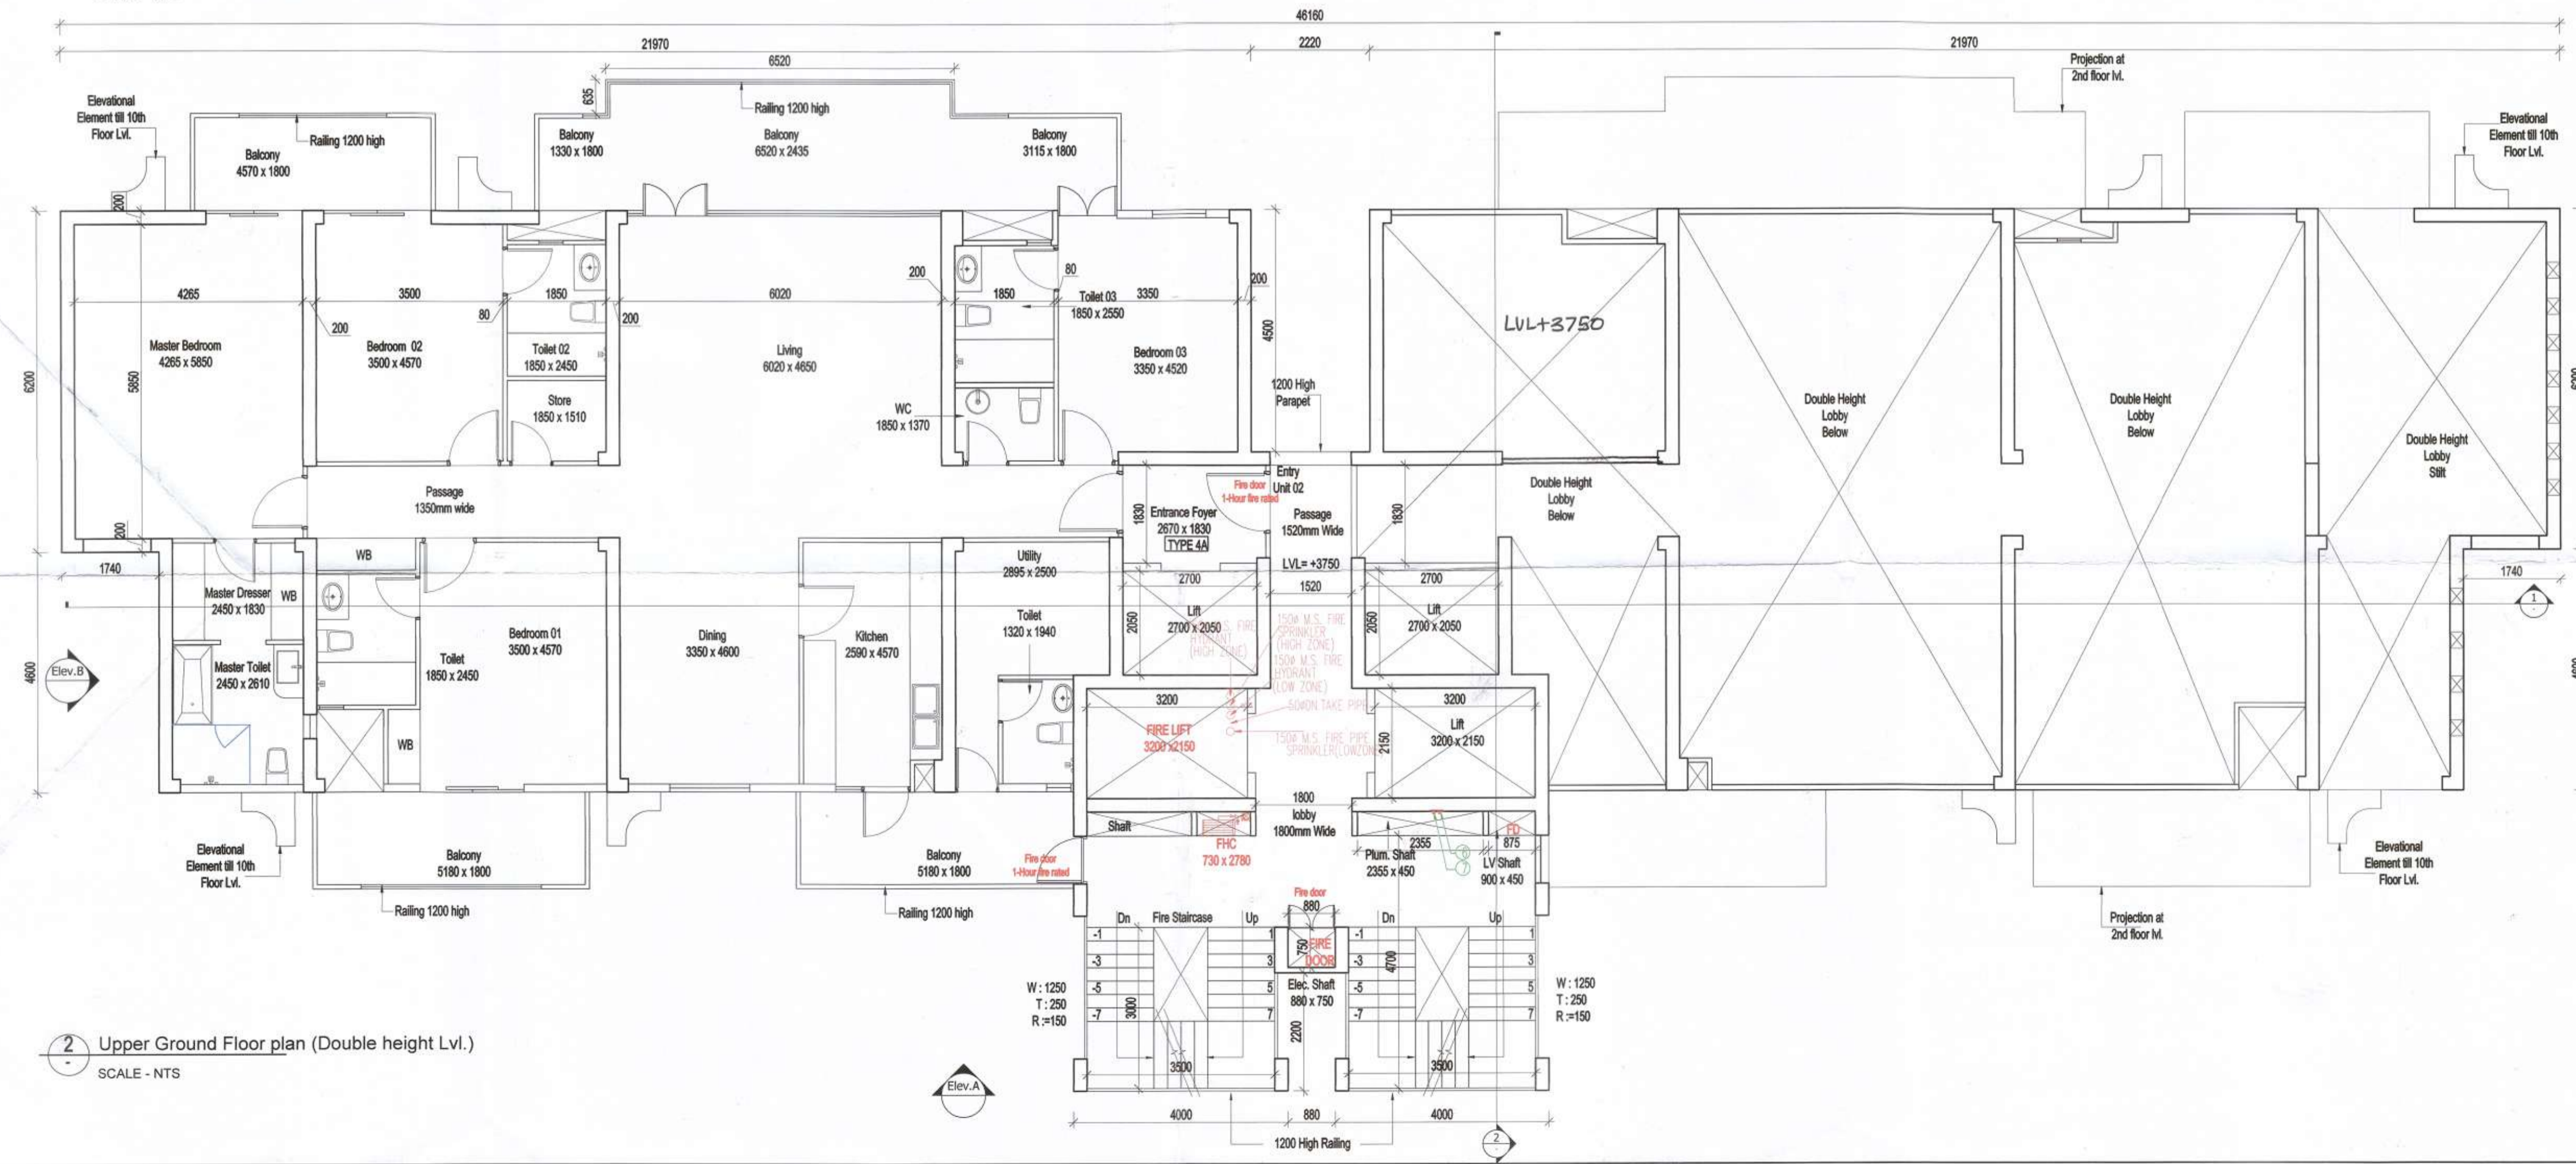

2 Upper Ground Floor plan (Double height Lvl.)
SCALE - NTS

LEGEND -

[Symbol]	FIRE HOSE CABINET
[Symbol]	9 L.P. WATER GAS PRESSURE TYPE FIRE EXTINGUISHER
[Symbol]	4.5 kg CO2 TYPE FIRE EXTINGUISHER
[Symbol]	FLOW INDICATING SWITCH

LEGEND -

1	110 OD SWR PVC SOIL & VENT PIPE
2	110 OD SWR PVC WASTE & VENT PIPE
3	90 OD SWR PVC ANTI-SYPHONAGE PIPE
4	110 OD uPVC RAIN WATER PIPE (FOR BALCONY)
5	110 OD uPVC RAIN WATER PIPE (FOR TERRACE)
[Symbol]	FLOOR TRAP
[Symbol]	FLOOR DRAIN

NOTE -
EACH FIRE HOSE CABINET SHALL CONSIST OF
1 No. - GUNMETAL SINGLE HEADED HYDRANT
2 Nos. - FIRE HOSES 63mm 15M LONG WITH
1 No. - SHORT BRANCH
1 No. - FIRST AID HOSE REEL
2 Nos. - FIRE EXTINGUISHERS
1 No. - FIRE MAN'S AXE

NOTE: TOWER 9 IS MIRROR OF TOWER 6

PROJECT TITLE
REVISED BUILDING PLANS OF MIXED LAND USE UNDER TOD SCHEME FOR AREA MEASURING 19.244 ACRES (LICENCE NO. 168-172 OF 2004, DATED 16/12/2004 & LICENCE NO. 545-546 OF 2006, DATED 13/03/2006) IN SECTOR- 53, GURUGRAM MANESAR URBAN COMPLEX BEING DEVELOPED BY M/S VIPUL LIMITED AND OTHERS.

DOOR/WINDOW SCHEDULE

SN	Type	Width (mm)	Chill (mm)	Lintel (mm)	Height (mm)
1	D1	1150	+00	+2400	2400
2	D2	1150	+00	+2400	2400
3	D3	1000	+00	+2400	2400
4	D4	800	+00	+2400	2400
5	D5	1105	+00	+2850 (BOB)	2850
6	D6	800	+00	+2100	2100
7	D7	890	+00	+2100	2100
8	W1	1500	+1000	+2850 (BOB)	1650
9	W2	1000	+1000	+2850 (BOB)	1650
10	W3	6000	+1000	+2850 (BOB)	1650
11	W4	1105	+1000	+2850 (BOB)	1650
12	W5	5870	+250	+2850 (BOB)	2400
13	W6	3950	+250	+2850 (BOB)	2400
14	W7	5270	+1000	+2850 (BOB)	1650
15	W8	2200	+1000	+2850 (BOB)	1650
16	V1	450	+1350	+2400	1050
17	DW1	5870	+00	+2850 (BOB)	2850
18	DW2	2005	+00	+2850 (BOB)	2850
19	DW3	1950	+00	+2850 (BOB)	2850
20	DW4	1390	+00	+2100	2100
21	DW5	1350	+00	+2850 (BOB)	2850
22	DW6	1800	+00	+2850 (BOB)	2850

SCALE 1:100
DATE AUG. 2021
DEALT SJ CHECKED MA

ARCHITECT **Design Axis architects**
T-134 A, AM BAGH FARM HOUSE, NEAR SHAMSHI TALAB ANDHERIA MORN, MEHRAULI, NEW DELHI - 110030
PH - 9811058563, 26644831, 26648146
EMAIL - designaxis2015@gmail.com

ARCHITECT & ID **designcosmos**
Architects & Interior Design Consultants
Second Floor A-609, Sushant Lok-I, Gurgaon.
Email : studio.designcosmos@gmail.com
Contact : 0124-4203676

ARCHITECT'S SIGN. **DESIGN AXIS ARCHITECTS & ENGINEERS NEW DELHI**

APPLICANT'S SIGN. **For VIPUL LIMITED**
Authorised Signatory