



This is a "PROVISIONAL BUILDING PLAN" approved by the purpose of inviting objections from the general public.

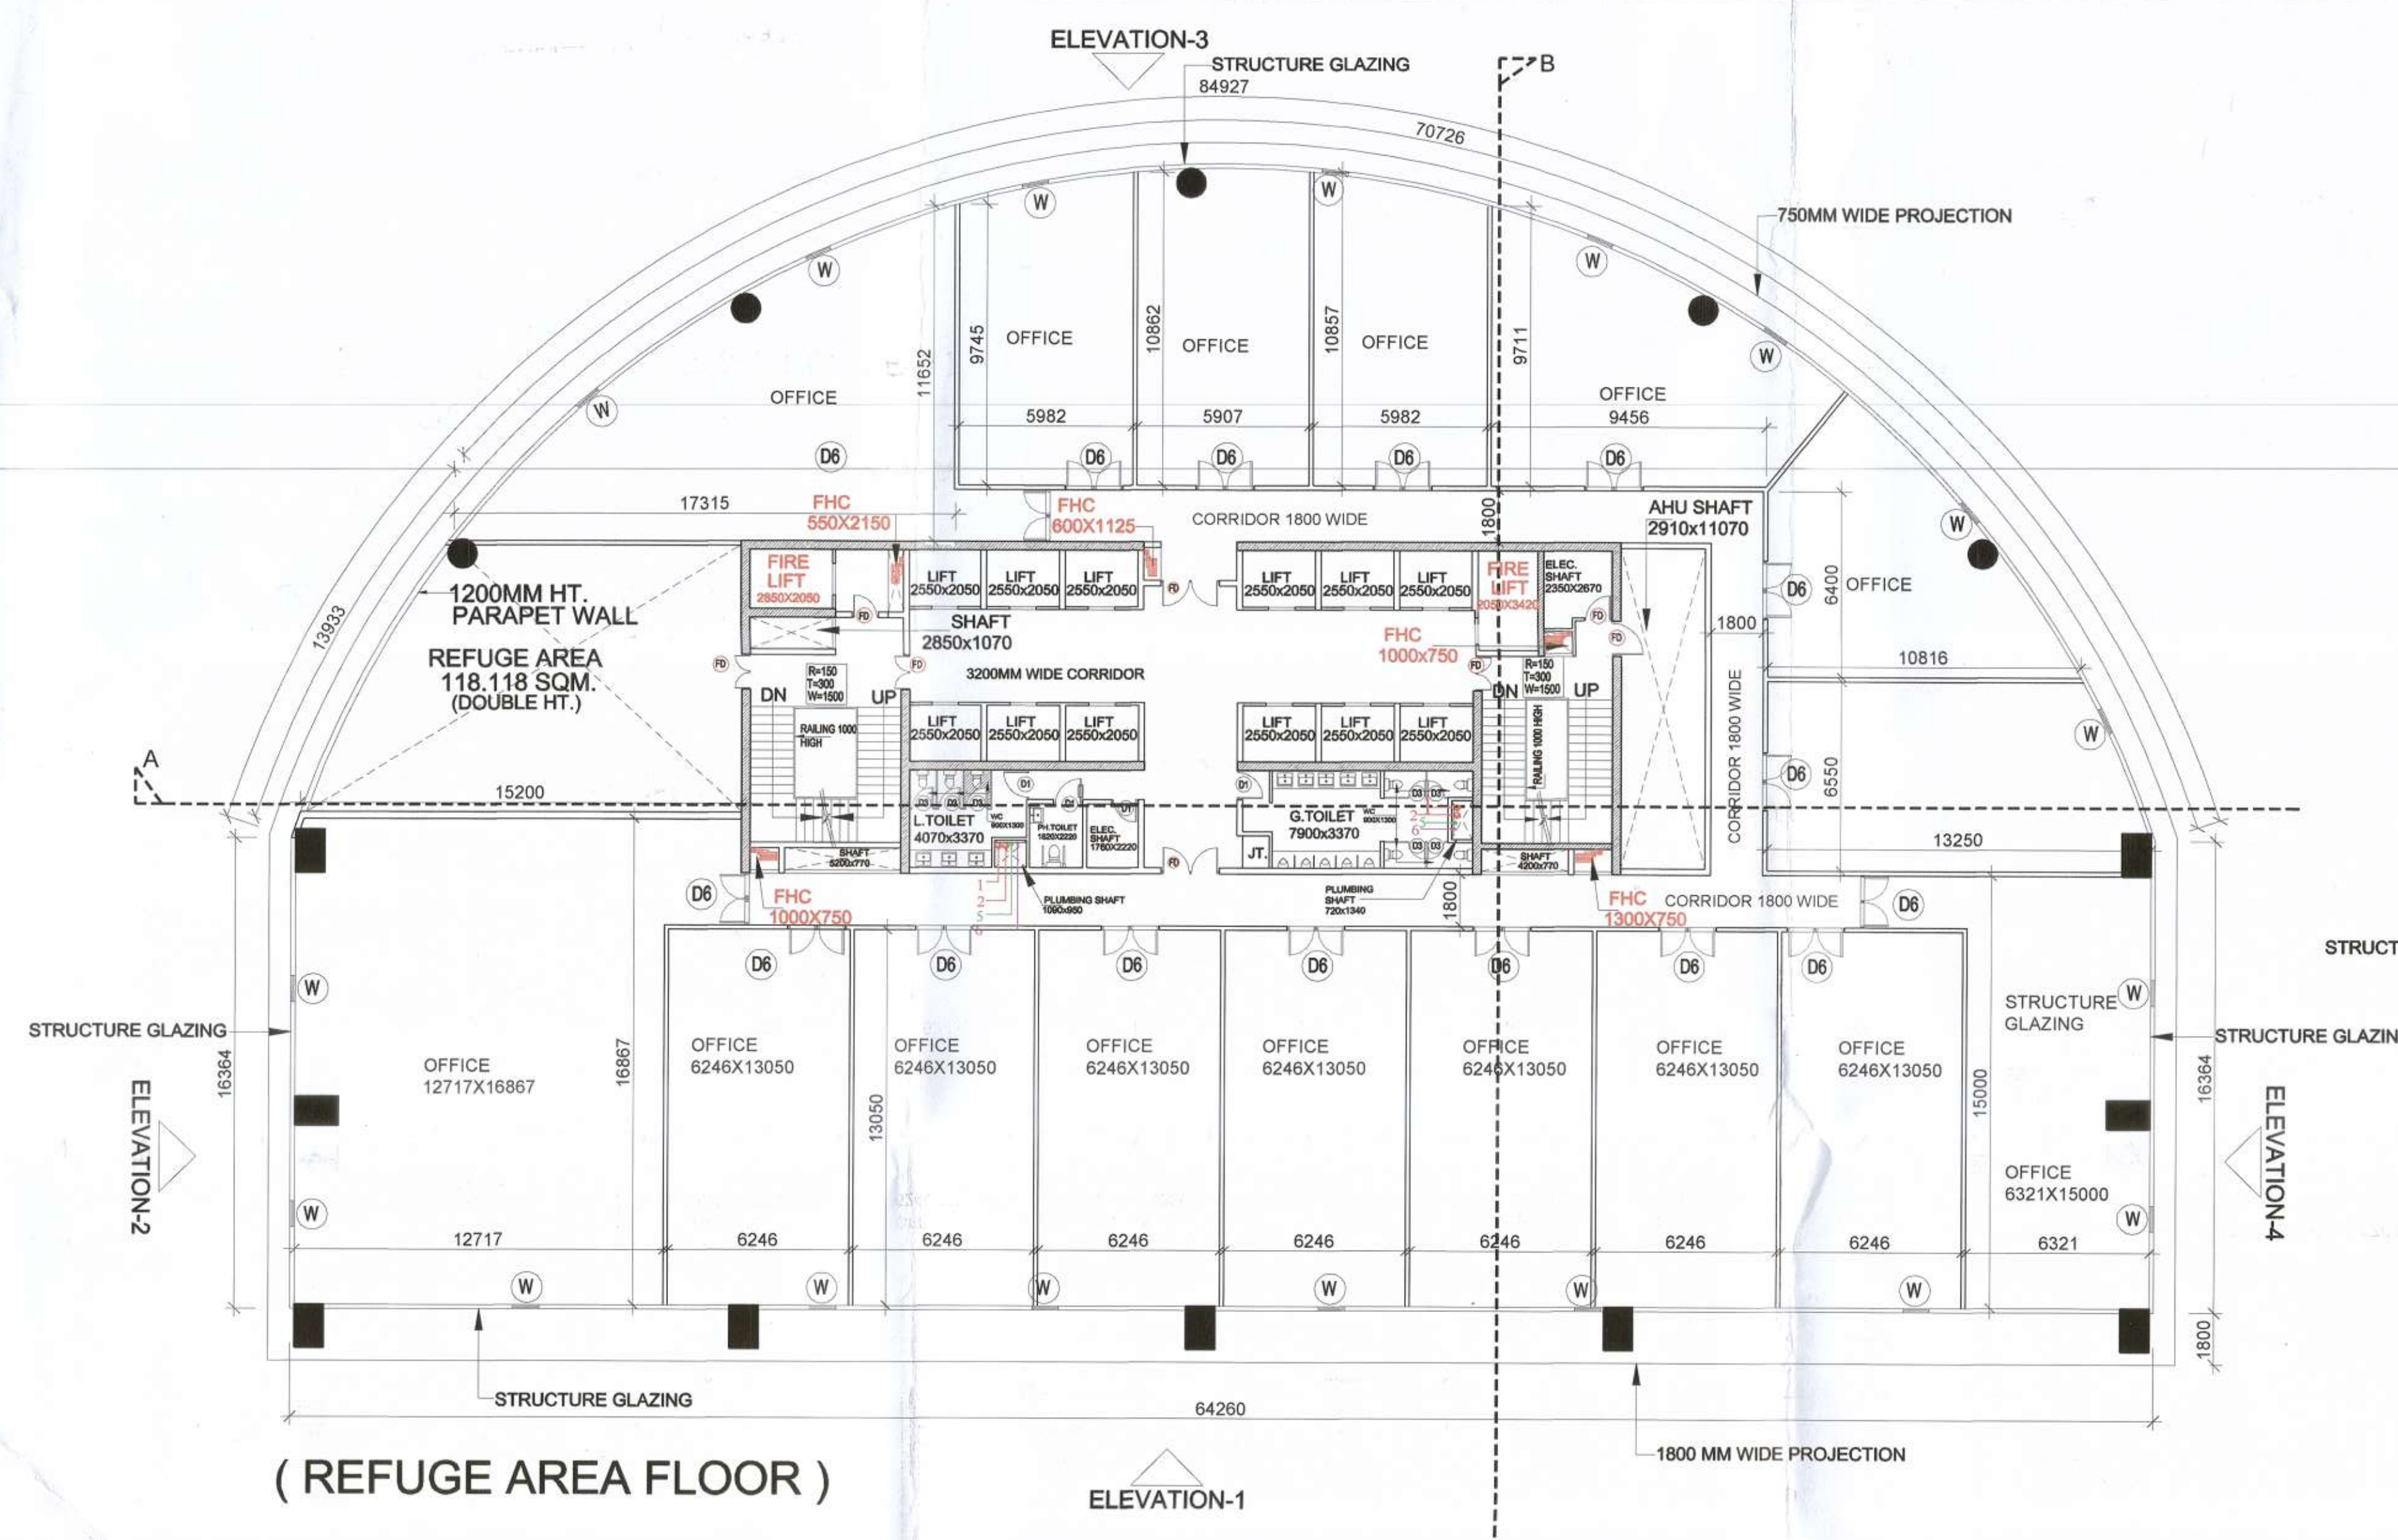


(REFUGE AREA FLOOR)

5th floor level - +25050
9th floor level - +43050
15th floor level - +70050

AREA DETAIL OF REFUGE AREA ON 4th FLOOR
REFUGE AREA REQUIRED :-
= 1953.642 (GROSS AREA OF TYPICAL FLOOR) X 2
= 3907.284/10.000 X 0.300
= 117.218 + 0.900
= 118.118 SQ.M.

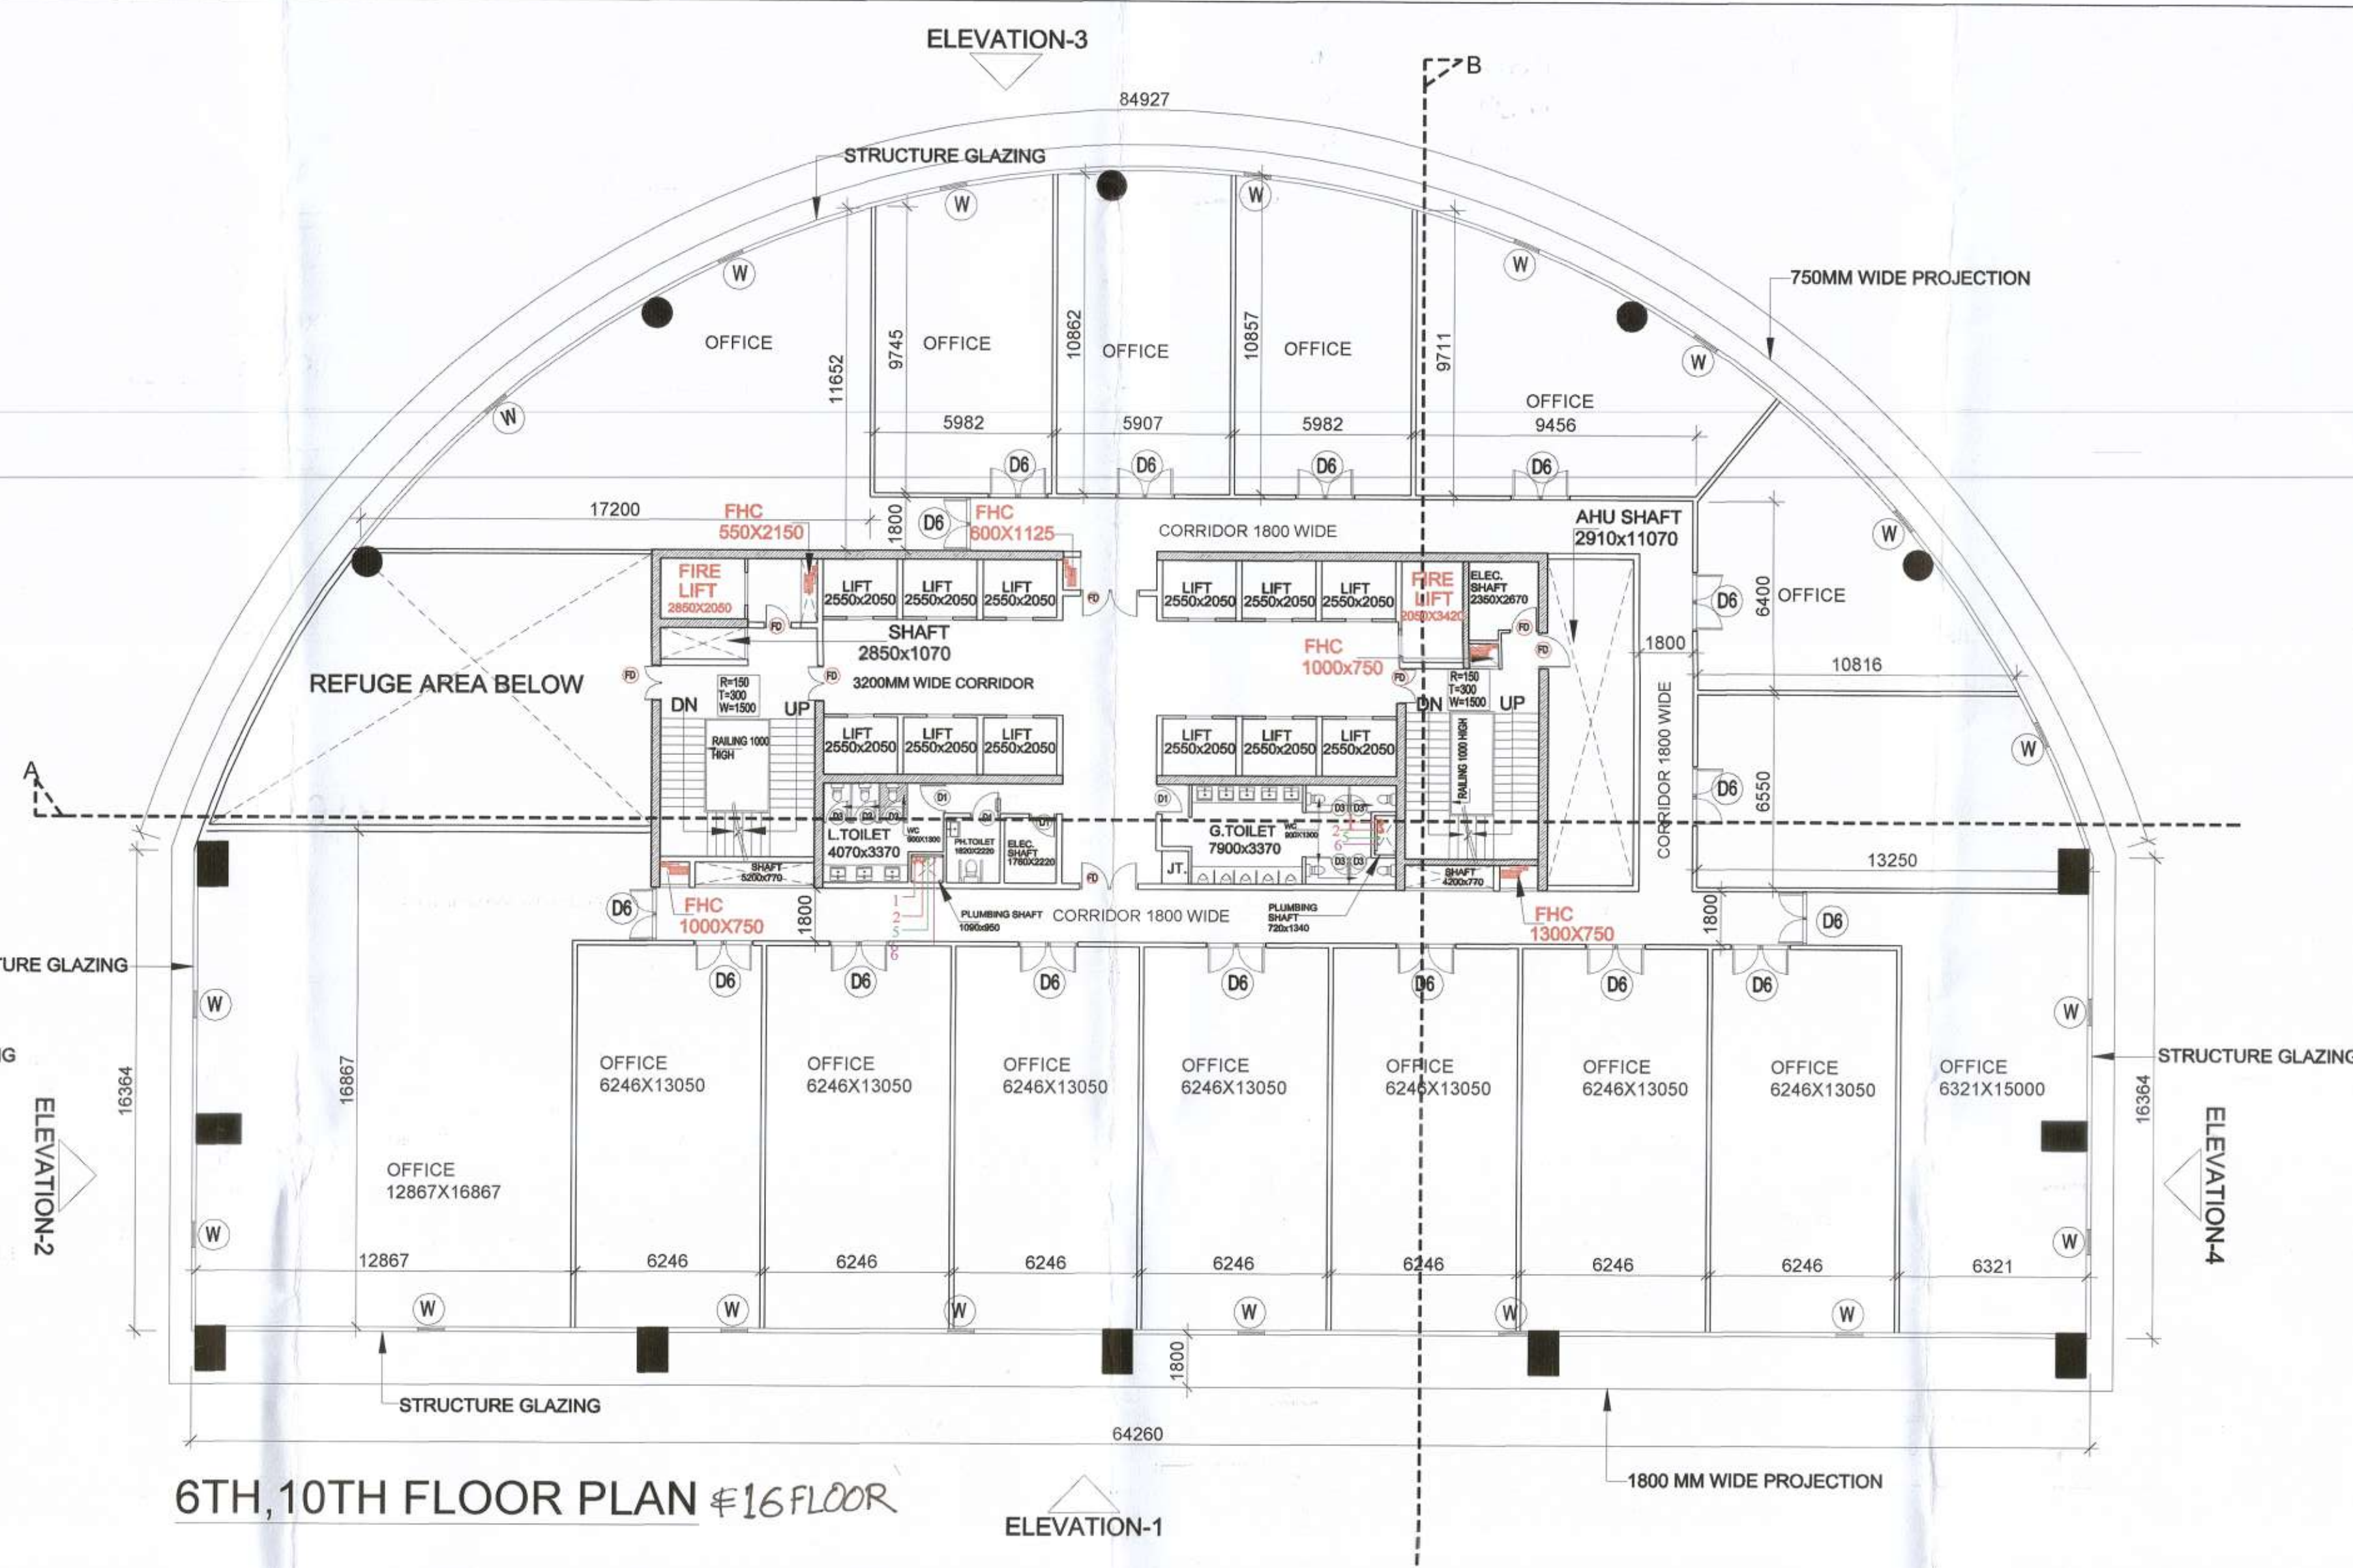

6TH, 10TH FLOOR PLAN #16 FLOOR

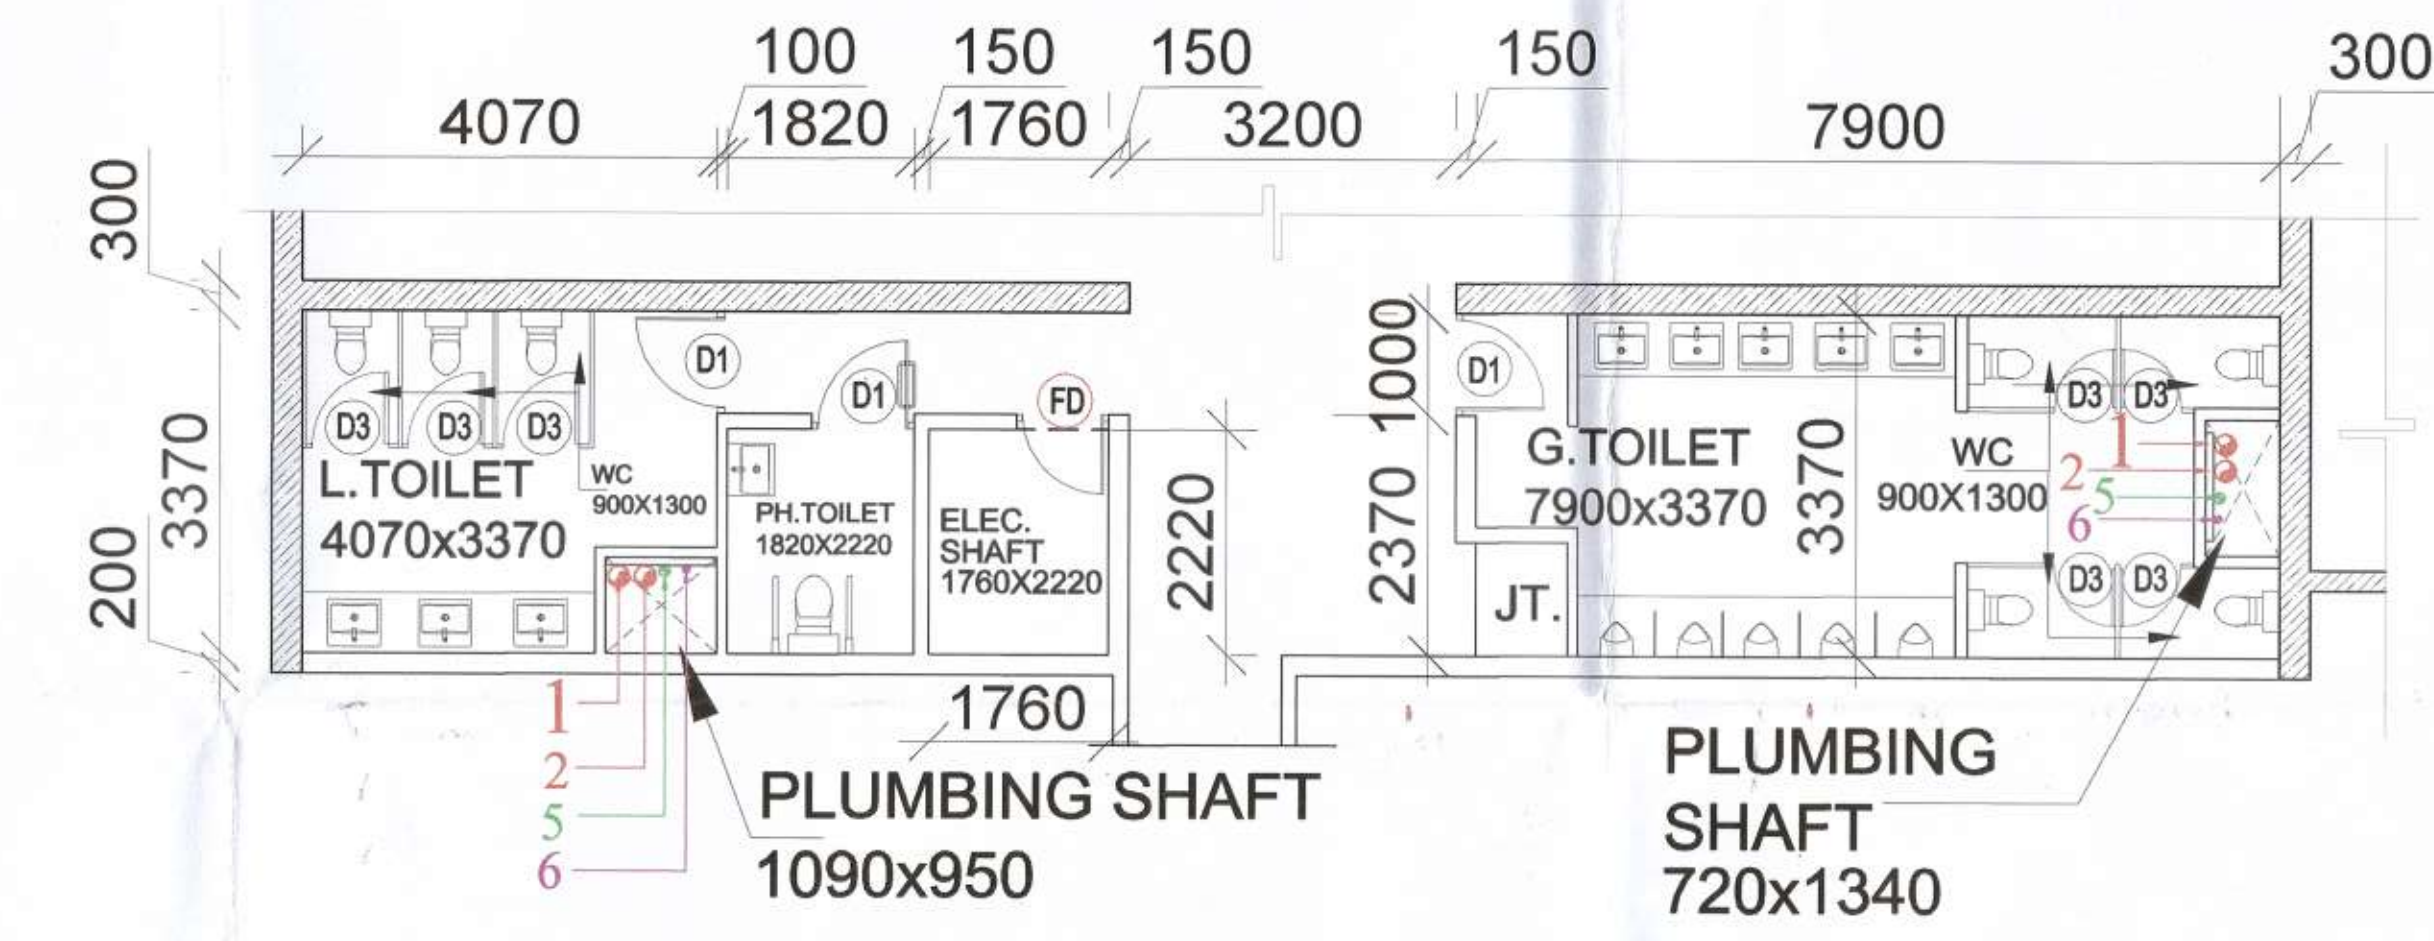


TOILET DETAIL

DOOR & WINDOW SCHEDULE				
Sr.NO.	TYPE	SIZE	LINTEL	
1.	D1	1000	2400	
2.	D2	900	2400	
3.	D3	750	2400	
4.	D4	800	2400	
4.	D5	1050	2400	
4.	D6	2000	2400	
4.	FD	1200	2400	
5.	V1	750 X 750		
6.	V2	1250 X 750		
7.	V3	1500 X 750		


SCHEDULE OF PLUMBING PIPES:-		
PIPE NO.	DESCRIPTION	DIA. (MM)
1	SOIL & VENT PIPE MAIN TOILET	100 Dia
2	WASTE & VENT PIPE	100 Dia
3	RAIN WATER PIPE FOR TERRACE	100 Dia
5	CWS DROP FROM OHT	
6	FWS DROP FROM OHT	
7	COLD WATER RISER TO OHT	
8	FLUSHING WATER RISER TO OHT	
	GULLY TRAP 300x300mm	Ø
	MANHOLE SEWER 600x600	Ø
	KHURRA SIZE- 450 X 450MM.	Ø
	CATCH BASIN - 500 X 450MM.	Ø

LEGEND FOR FIRE FIGHTING	
DESCRIPTION	SYMBOL
8- WET RISER FOR FIRE HYDRANTS	150 Dia
FIRE HOSE CABINET	FHC
FIRE EXTINGUISHER	ABC POWDER TYPE - CAP. 6KG.
FIRE EXTINGUISHER	BC POWDER TYPE - CAP. 9KG.
MANUAL CALL POINT	
HOOTER	
FIREMAN'S JACK	

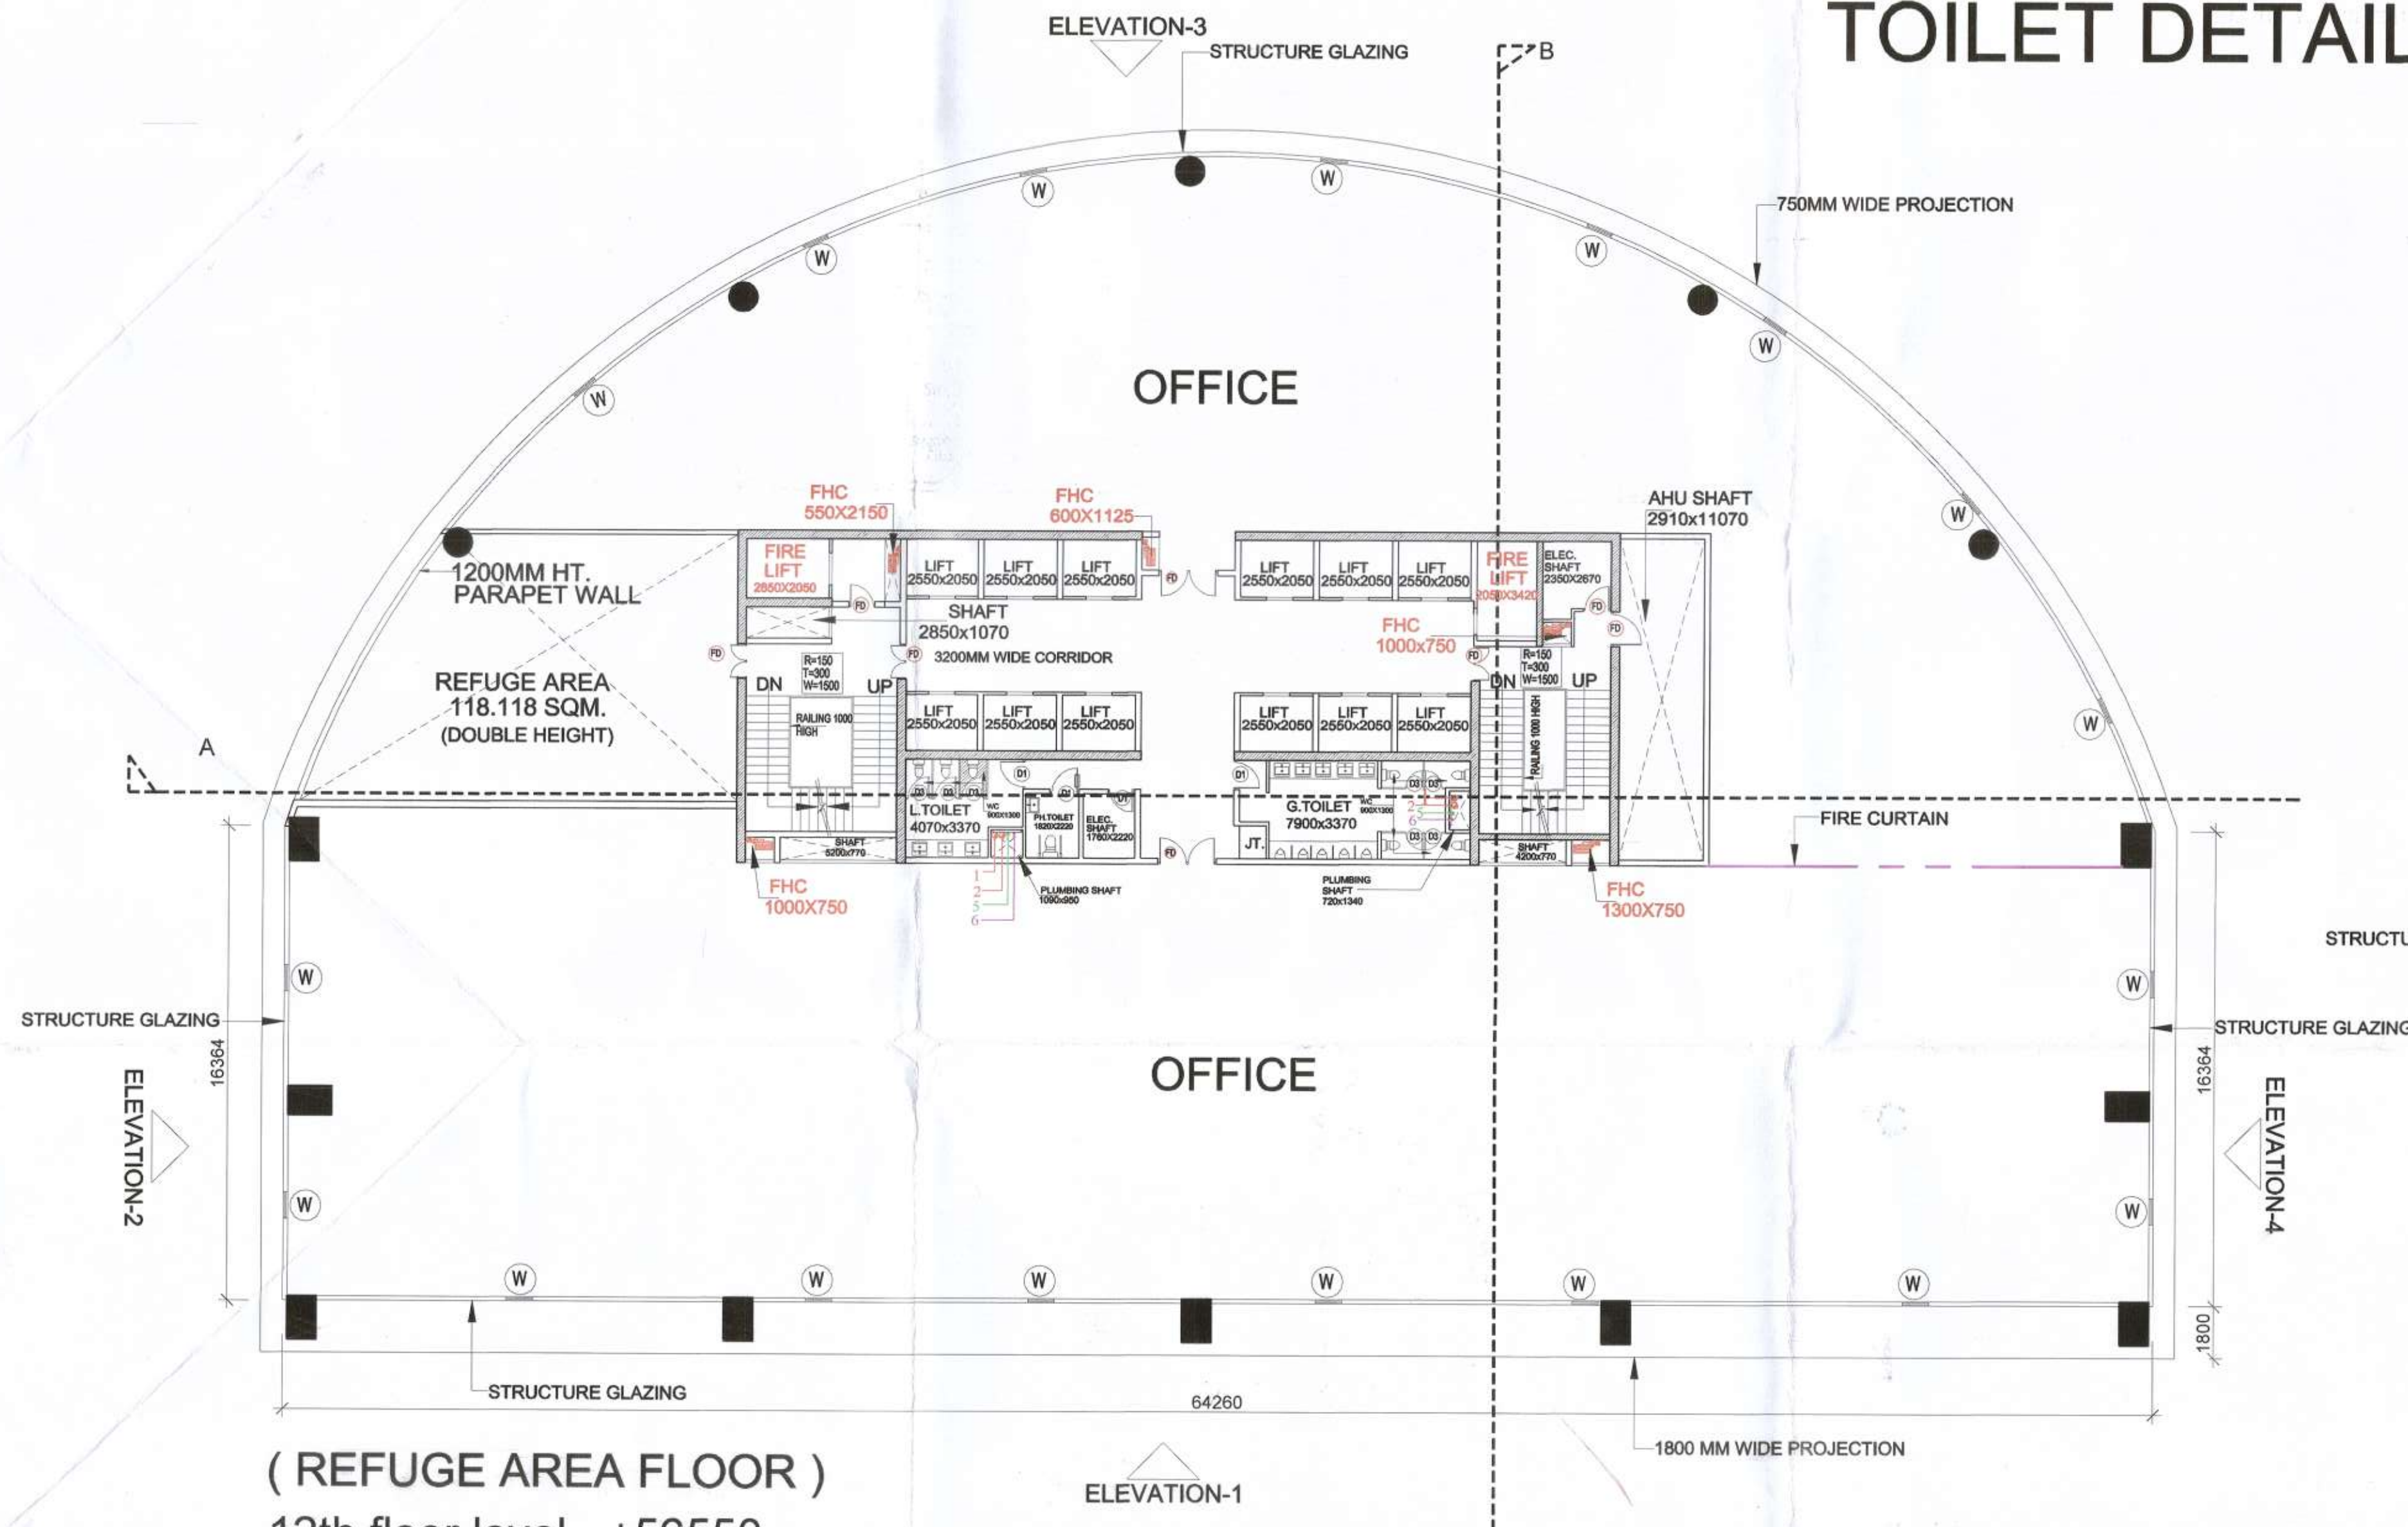

(REFUGE AREA FLOOR)

12th floor level - +56550

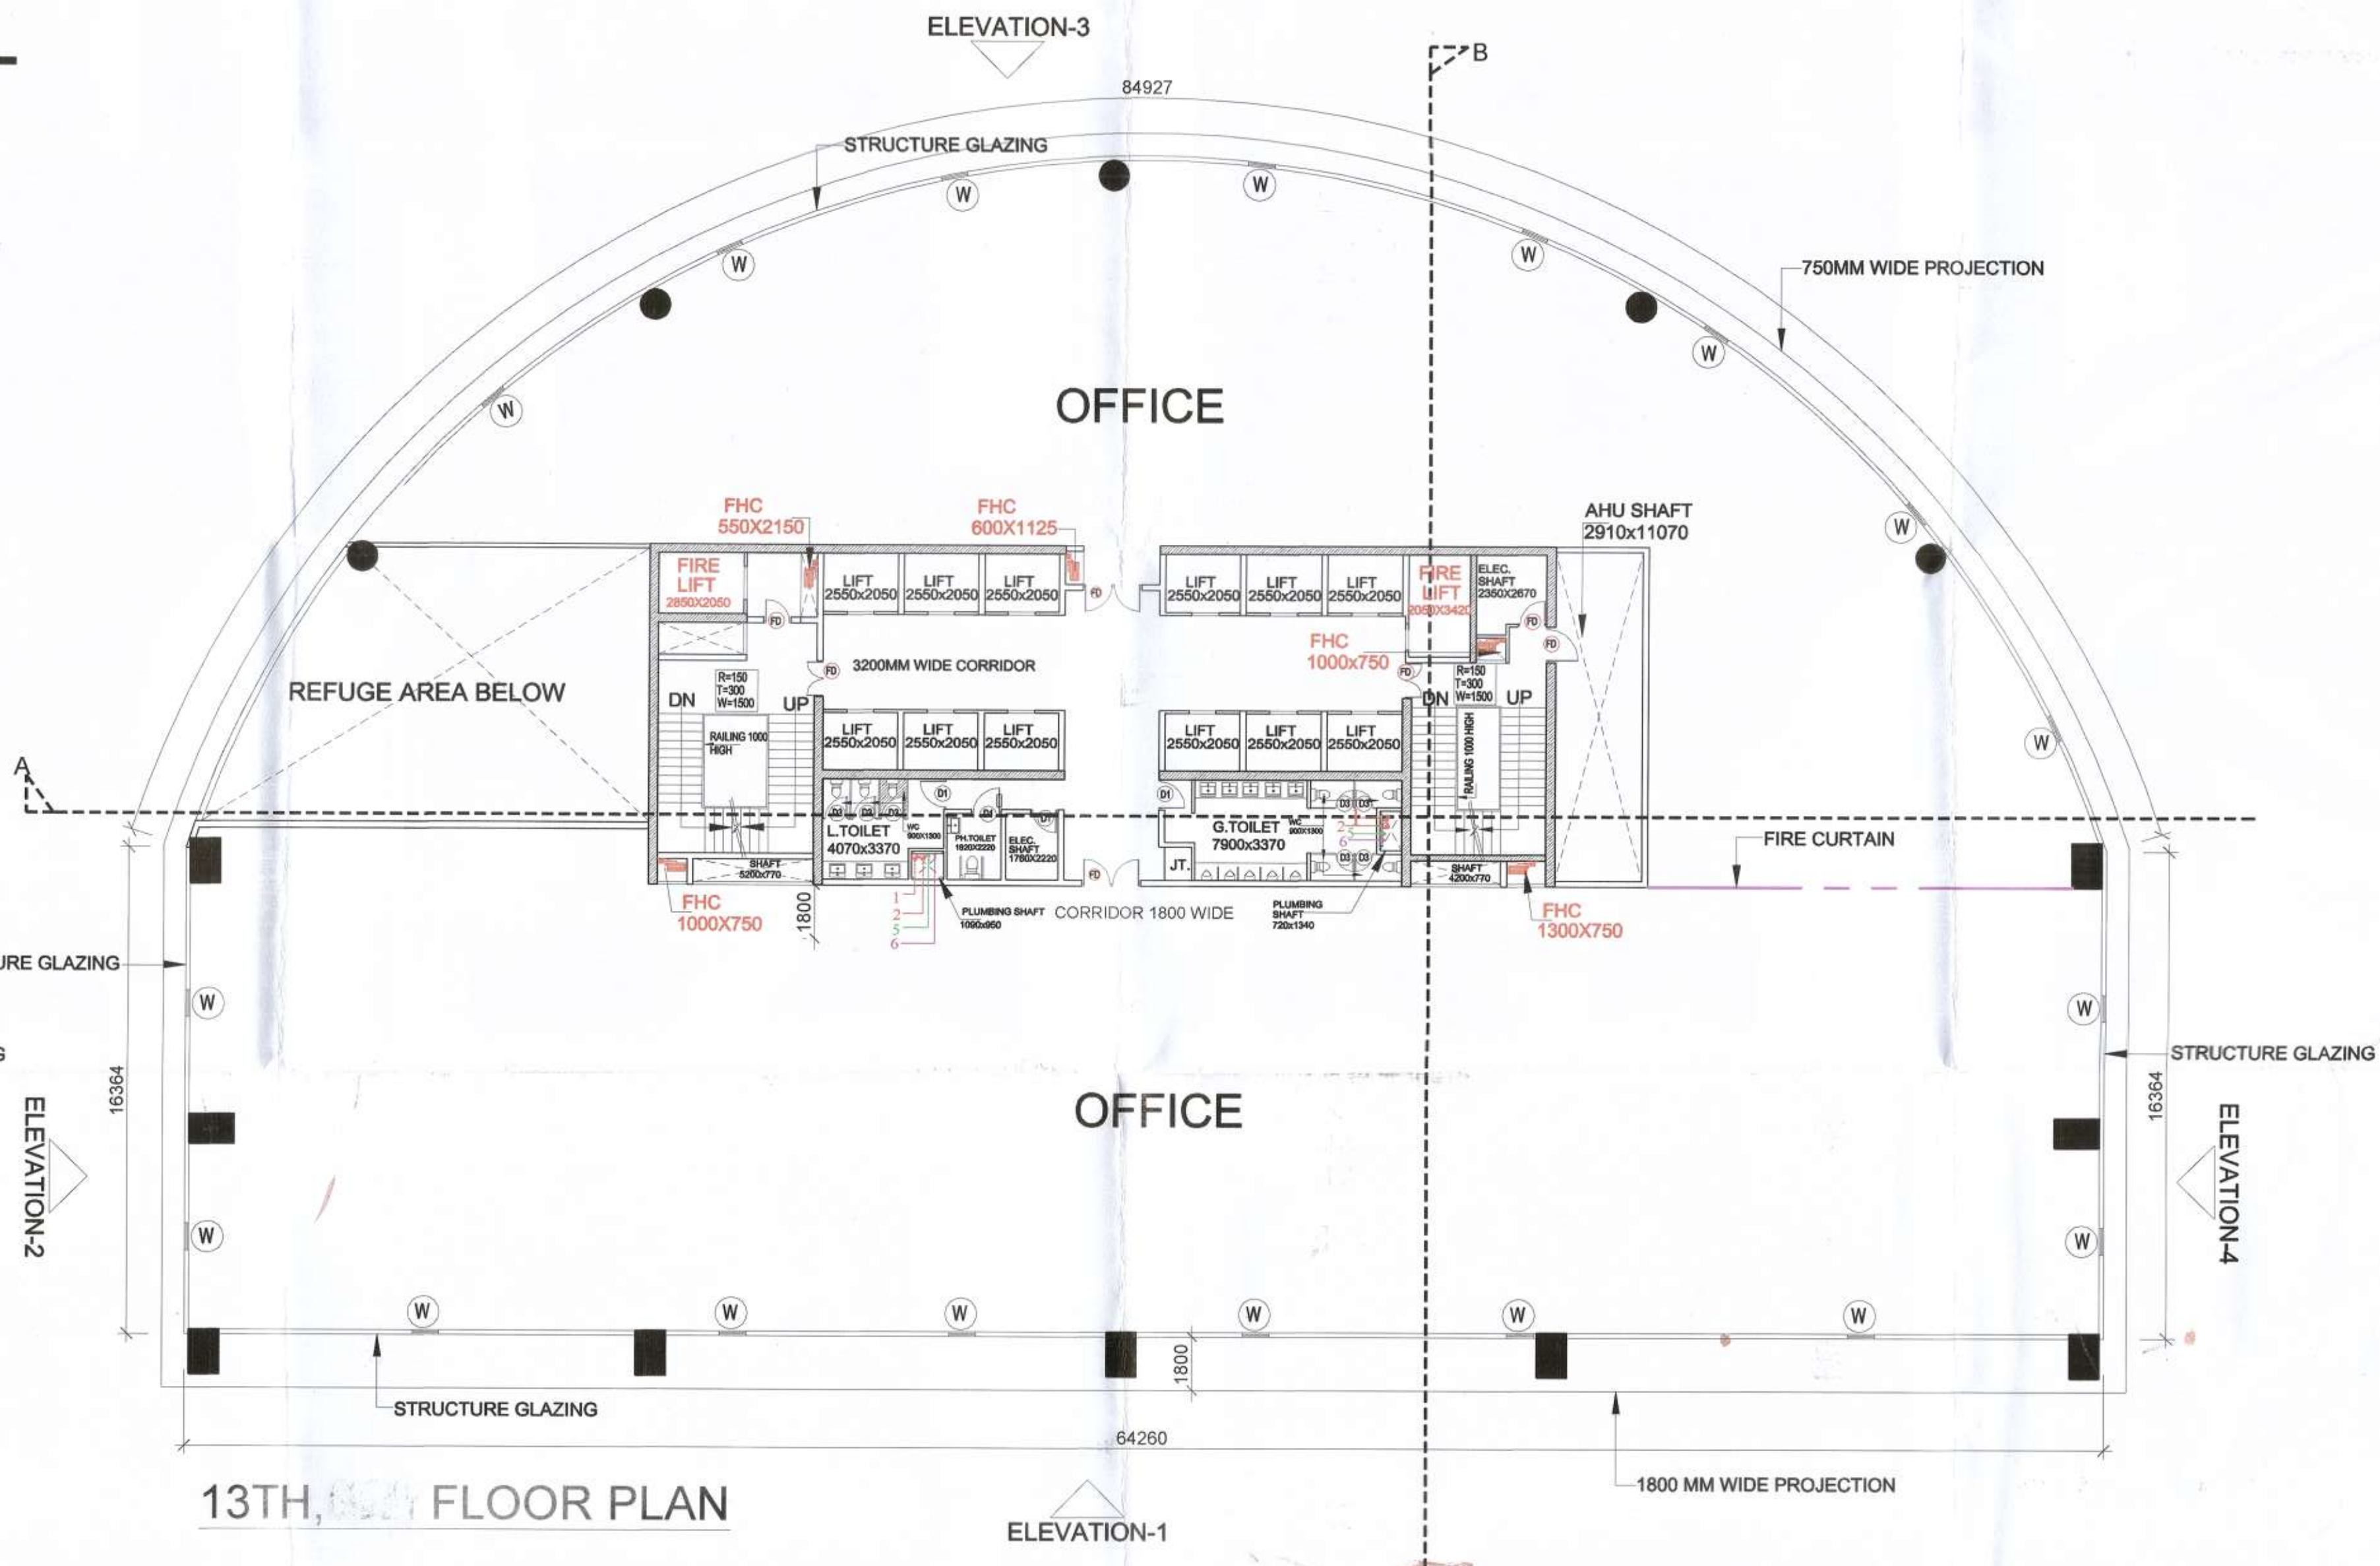

13TH FLOOR PLAN

NOTE:- ALL FD DOOR IS 1HR. FIRE RATED
OPENABLE WINDOW AT EVERY 10M

PROJECT TITLE: REVISED BUILDING PLANS OF MIXED LAND USE UNDER TOD SCHEME FOR AREA MEASURING 19.244 ACRES (LICENCE NO. 168-172 OF 2004, DATED 16/12/2004 & LICENCE NO. 545-546 OF 2006, DATED 13/03/2006) IN SECTOR- 53, GURUGRAM MANESAR URBAN COMPLEX BEING DEVELOPED BY M/S VIPUL LIMITED AND OTHERS.

SCALE: 1:150

DATE: AUG. 2021

DEALT: J.P. SHARMA CHECKED: VG

ARCHITECT: Design Axis architects

T-134 A, AM BAGH FARM HOUSE, NEAR SHAMSHI TALAB ANDHERIA MORH, MEHRAULI, NEW DELHI - 110030
PH - 9811058563, 26644831, 26648146
EMAIL - designaxis2015@gmail.com

ARCHITECT'S ID: designcosmos

Architects & Interior Design Consultants
Second Floor, A-609, Sushant Lok-I, Gurgaon.
Email: studio.designcosmos@gmail.com
Contact: 0124-4203676

ARCHITECT'S SIGN.

APPLICANT'S SIGN.