



14TH, TYPICAL FLOOR PLAN

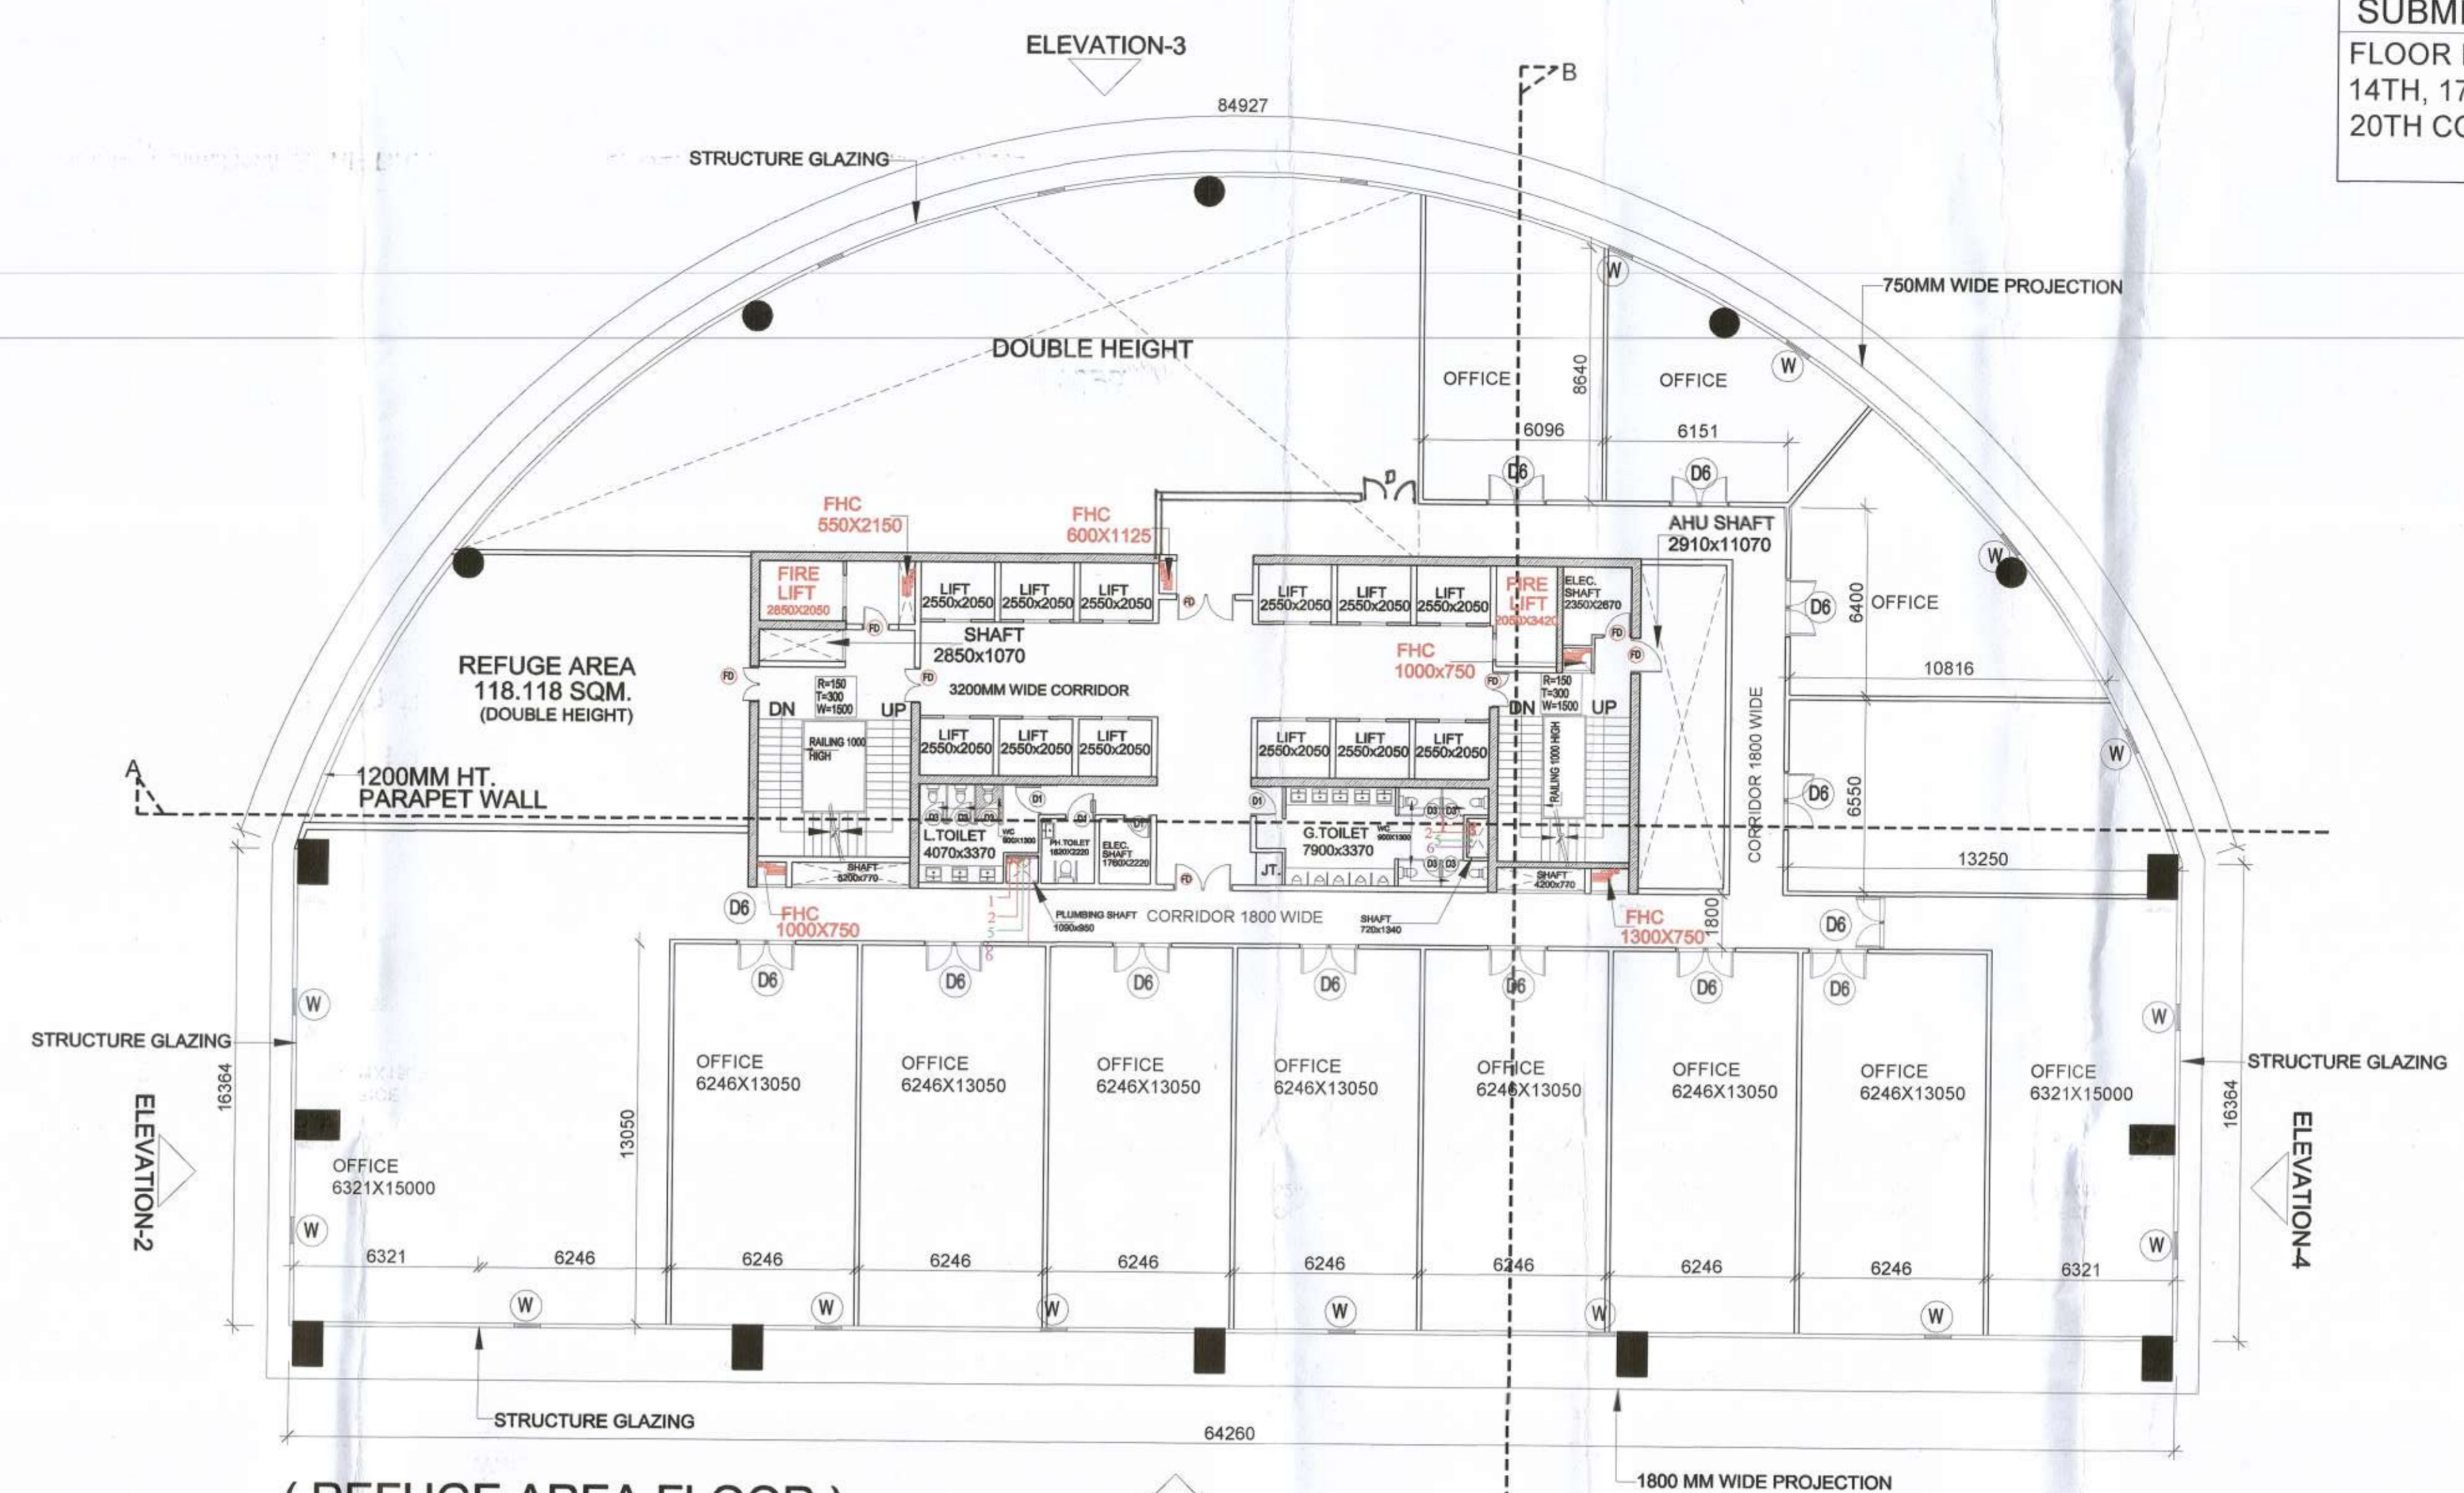

(REFUGE AREA FLOOR)
19th floor level - +88050

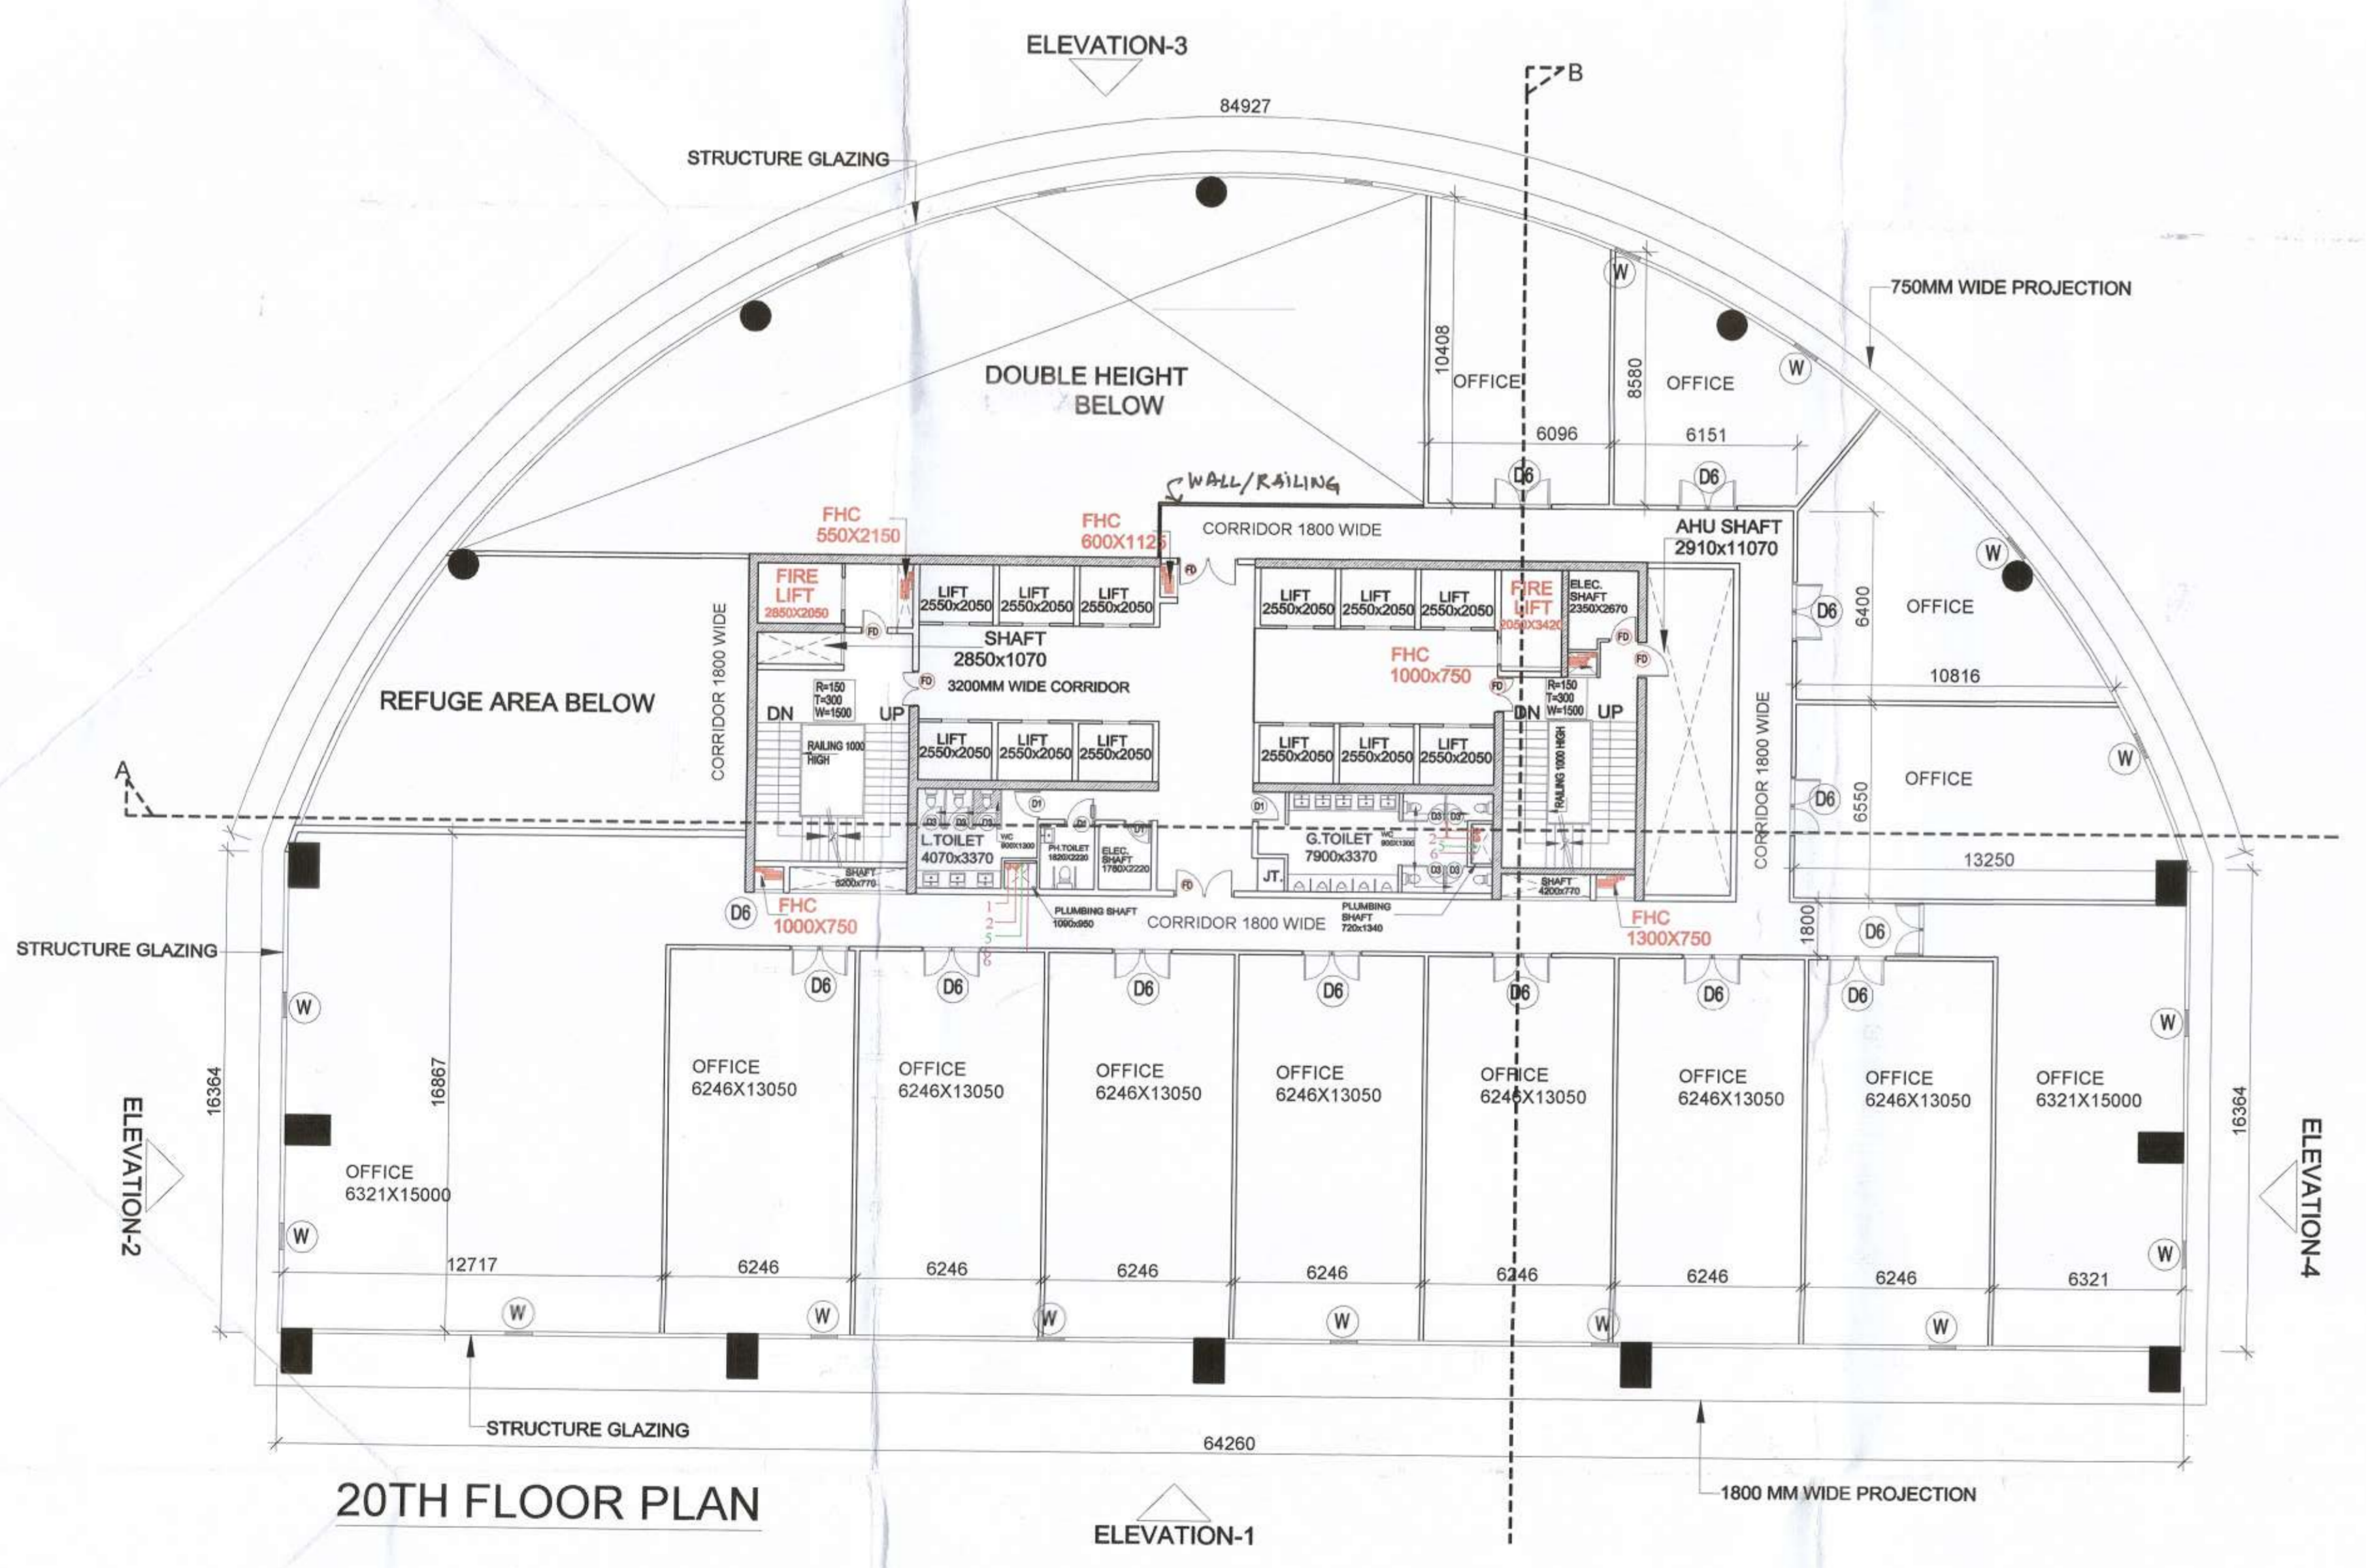

20TH FLOOR PLAN

DOOR & WINDOW SCHEDULE			
Sr.NO.	TYPE	SIZE	LINTEL
1.	D1	1000	2400
2.	D2	900	2400
3.	D3	750	2400
4.	D4	800	2400
4.	D5	1050	2400
4.	D6	2000	2400
4.	FD	1200	2400
4.	W	900X2400	
5.	V1	750 X750	
6.	V2	1250X750	
7.	V3	1500X750	
8.	DW1	2700	2400
9.	DW2	2400	2400
	W1	1250X1650	2400

SCHEDULE OF PLUMBING PIPES:-		
PIPE NO.	DESCRIPTION	DIA. (MM)
1	SOIL & VENT PIPE MAIN TOILET	100 Dia
2	WASTE & VENT PIPE	100 Dia
3	RAIN WATER PIPE FOR TERRACE	100 Dia
5	CWS DROP FROM OHT	
6	FWS DROP FROM OHT	
7	COLD WATER RISER TO OHT	
8	FLUSHING WATER RISER TO OHT	
	GULLY TRAP 300x300mm	
	MANHOLE SEWER 600x600	
	KHURRA SIZE- 450 X 450MM.	
	CATCH BASIN - 500 X 450MM.	

LEGEND FOR FIRE FIGHTING	
DESCRIPTION	SYMBOL
8- WET RISER FOR FIRE HYDRANTS	150 Dia
FIRE HOSE CABINET	FHC
FIRE EXTINGUISHER	
ABC POWDER TYPE - CAP. 6KG.	
FIRE EXTINGUISHER	
BC POWDER TYPE -CAP. 9KG.	
MANUAL CALL POINT	
HOOTER	
FIREMAN'S JACK	

This is a "PROVISIONAL BUILDING PLAN" approved only for the purpose of inviting objections from the general public.

Checked and found ok for Public Meeting (Internal) Service only - not to be used in the field.

Additional Copy (H&S) : NSVP, Panaji

Member Secretary NSVP

Run Arav Basal AD(HQ)

PROJECT TITLE
REVISED BUILDING PLANS OF MIXED LAND USE UNDER TOD SCHEME FOR AREA MEASURING 19.244 ACRES (LICENCE NO. 168-172 OF 2004, DATED 16/12/2004 & LICENCE NO. 545-546 OF 2006, DATED 13/03/2006) IN SECTOR- 53, GURUGRAM MANESAR URBAN COMPLEX BEING DEVELOPED BY M/S VIPUL LIMITED AND OTHERS.

SCALE 1:150

DATE AUG. 2021

DEALT J.P SHARMA CHECKED VG

ARCHITECT **Design Axis architects**

T-13/A, AM BAGH FARM HOUSE, NEAR SHAMSH TALAB ANDHERA NORTH, MEHRALLI, NEW DELHI - 110030
PH - 9811058563, 28644831, 28648146
EMAIL - designaxis2015@gmail.com

ARCHITECT & ID **designcosmos**

Architects & Interior Design Consultants
Second Floor, A-609, Sushant Lok-I, Gurgaon.
Email : studio.designcosmos@gmail.com
Contact : 0124-4203676

ARCHITECT'S SIGN.

APPLICANT'S SIGN.

For VIPUL LIMITED
Authorised Signatory

NOTE:- ALL FD DOOR IS 1HR. FIRE RATED
OPENABLE WINDOW AT EVERY 10M